 


FLOOR PLAN - DIMENSION

SCALE = 1:100




MACO
DESIGNS

Contact: 7989966, 7691671


Email: info@maco.mv

C1

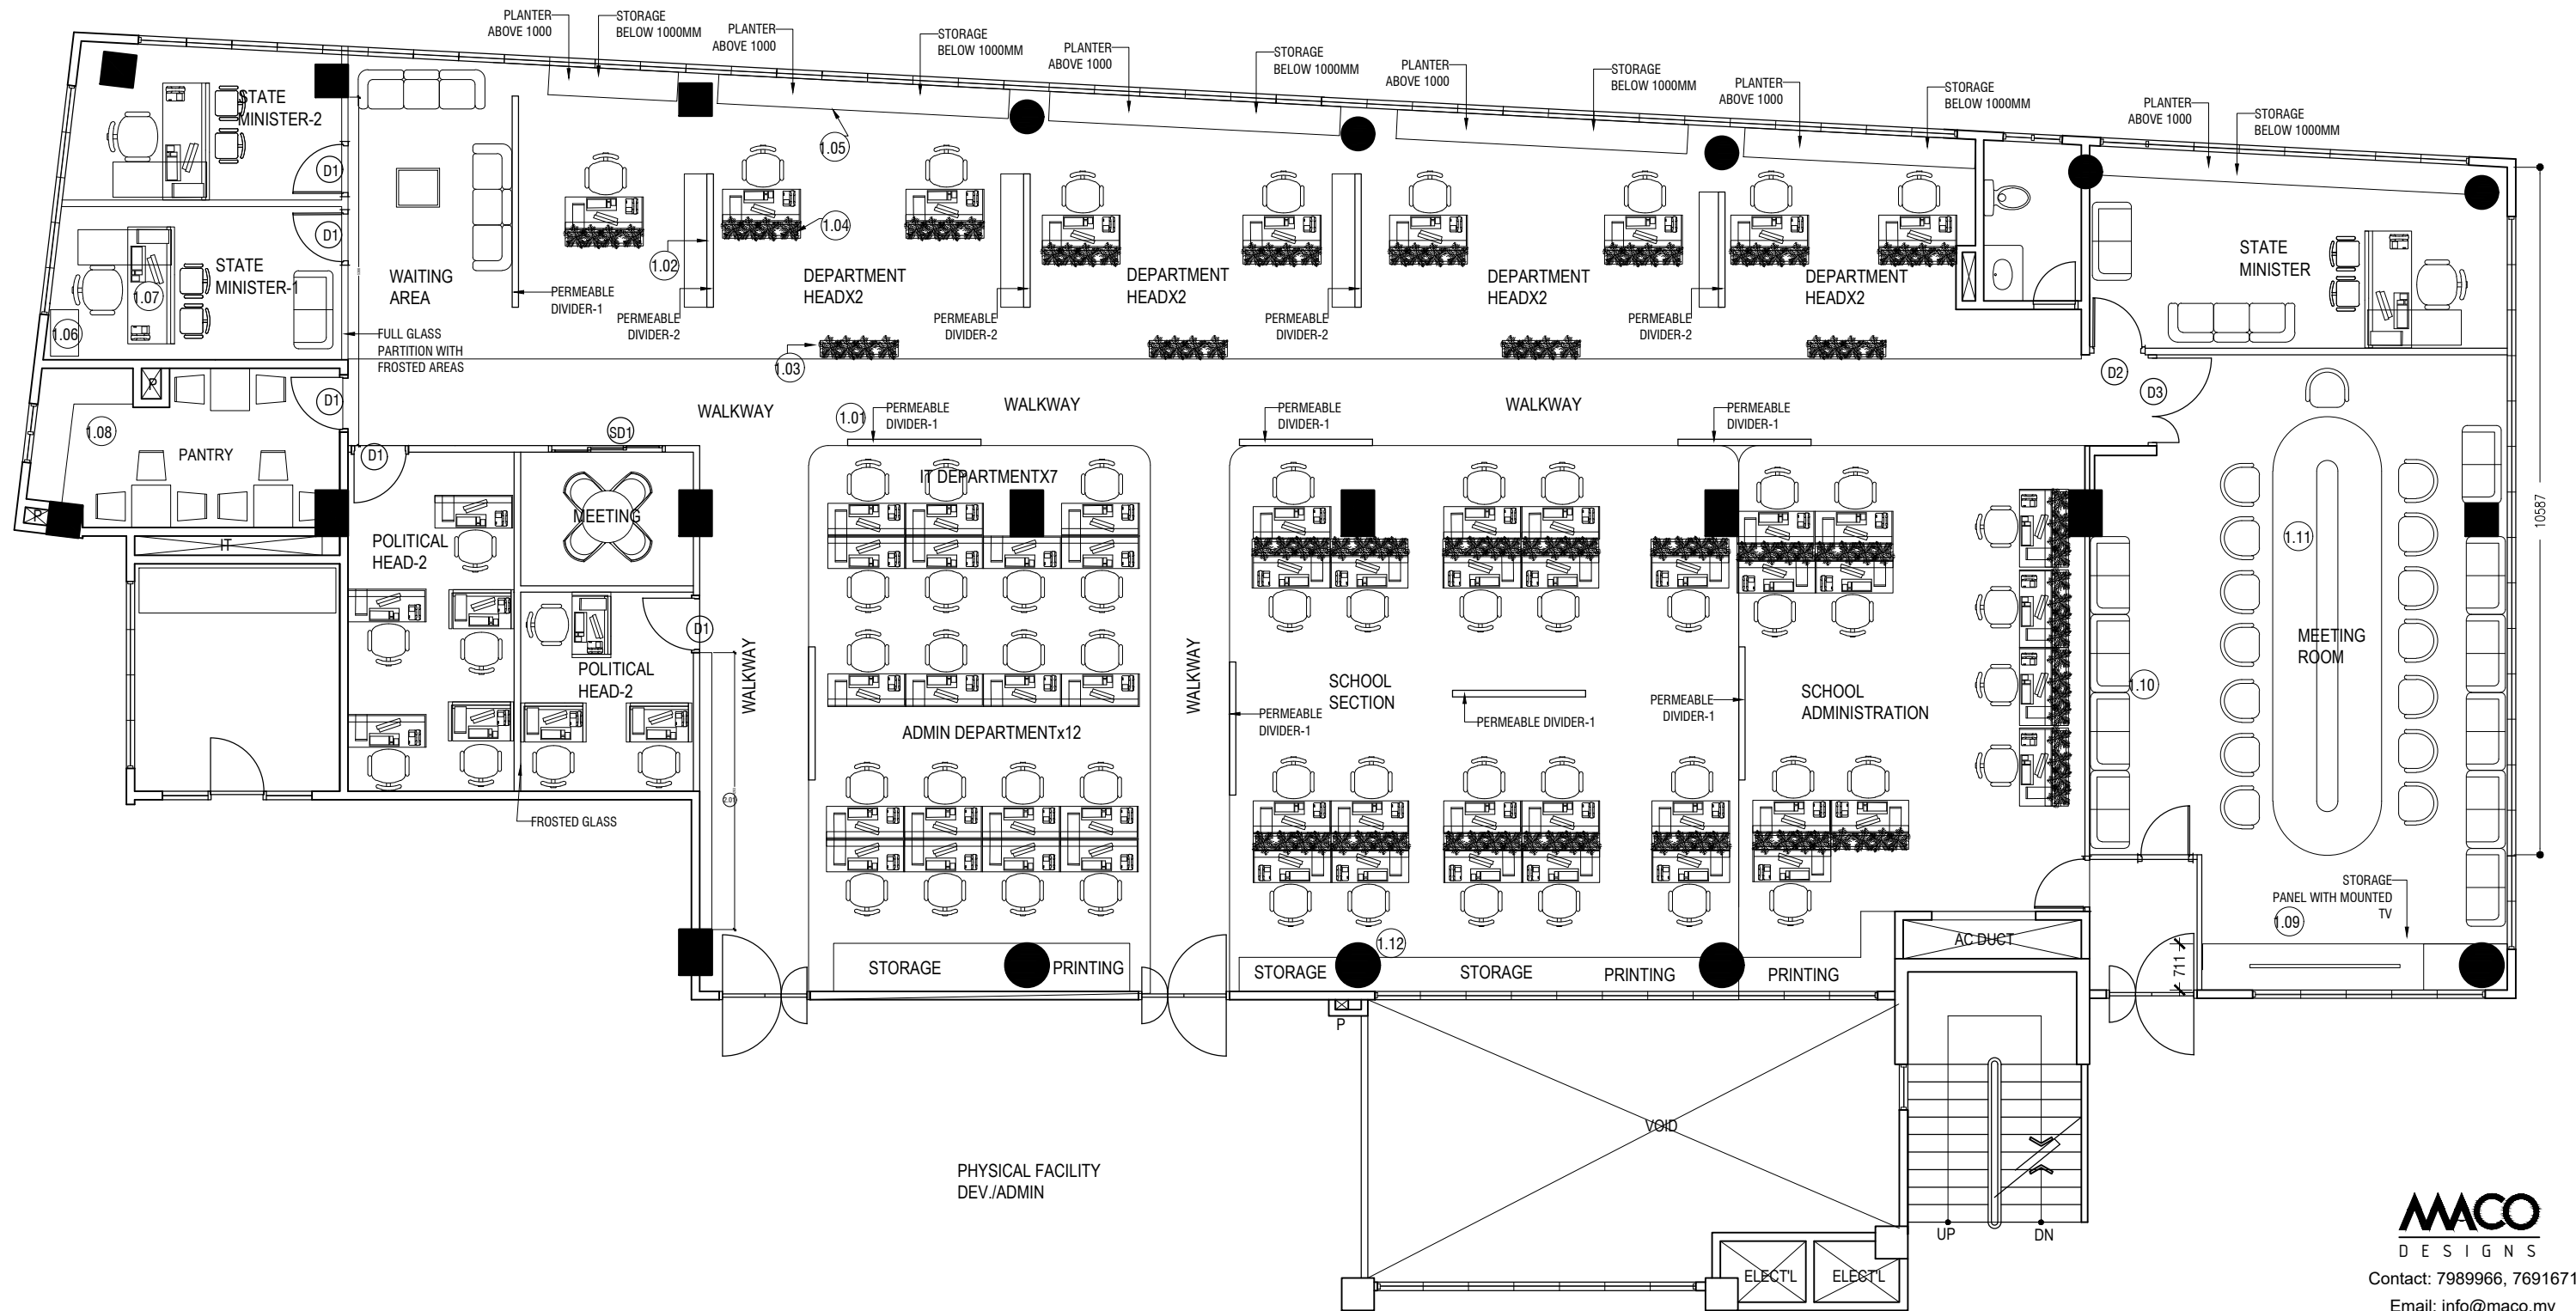

FLOOR PLAN - FURNITURE

 SCALE = 1:100



MACO
DESIGNS


Contact: 7989966, 7691671

Email: info@maco.mv


C2



LEGEND		
SYMBOL	HATCH	FINISH
C1		GREY CARPET REF#6.01
C2		BLUE CARPET REF#602

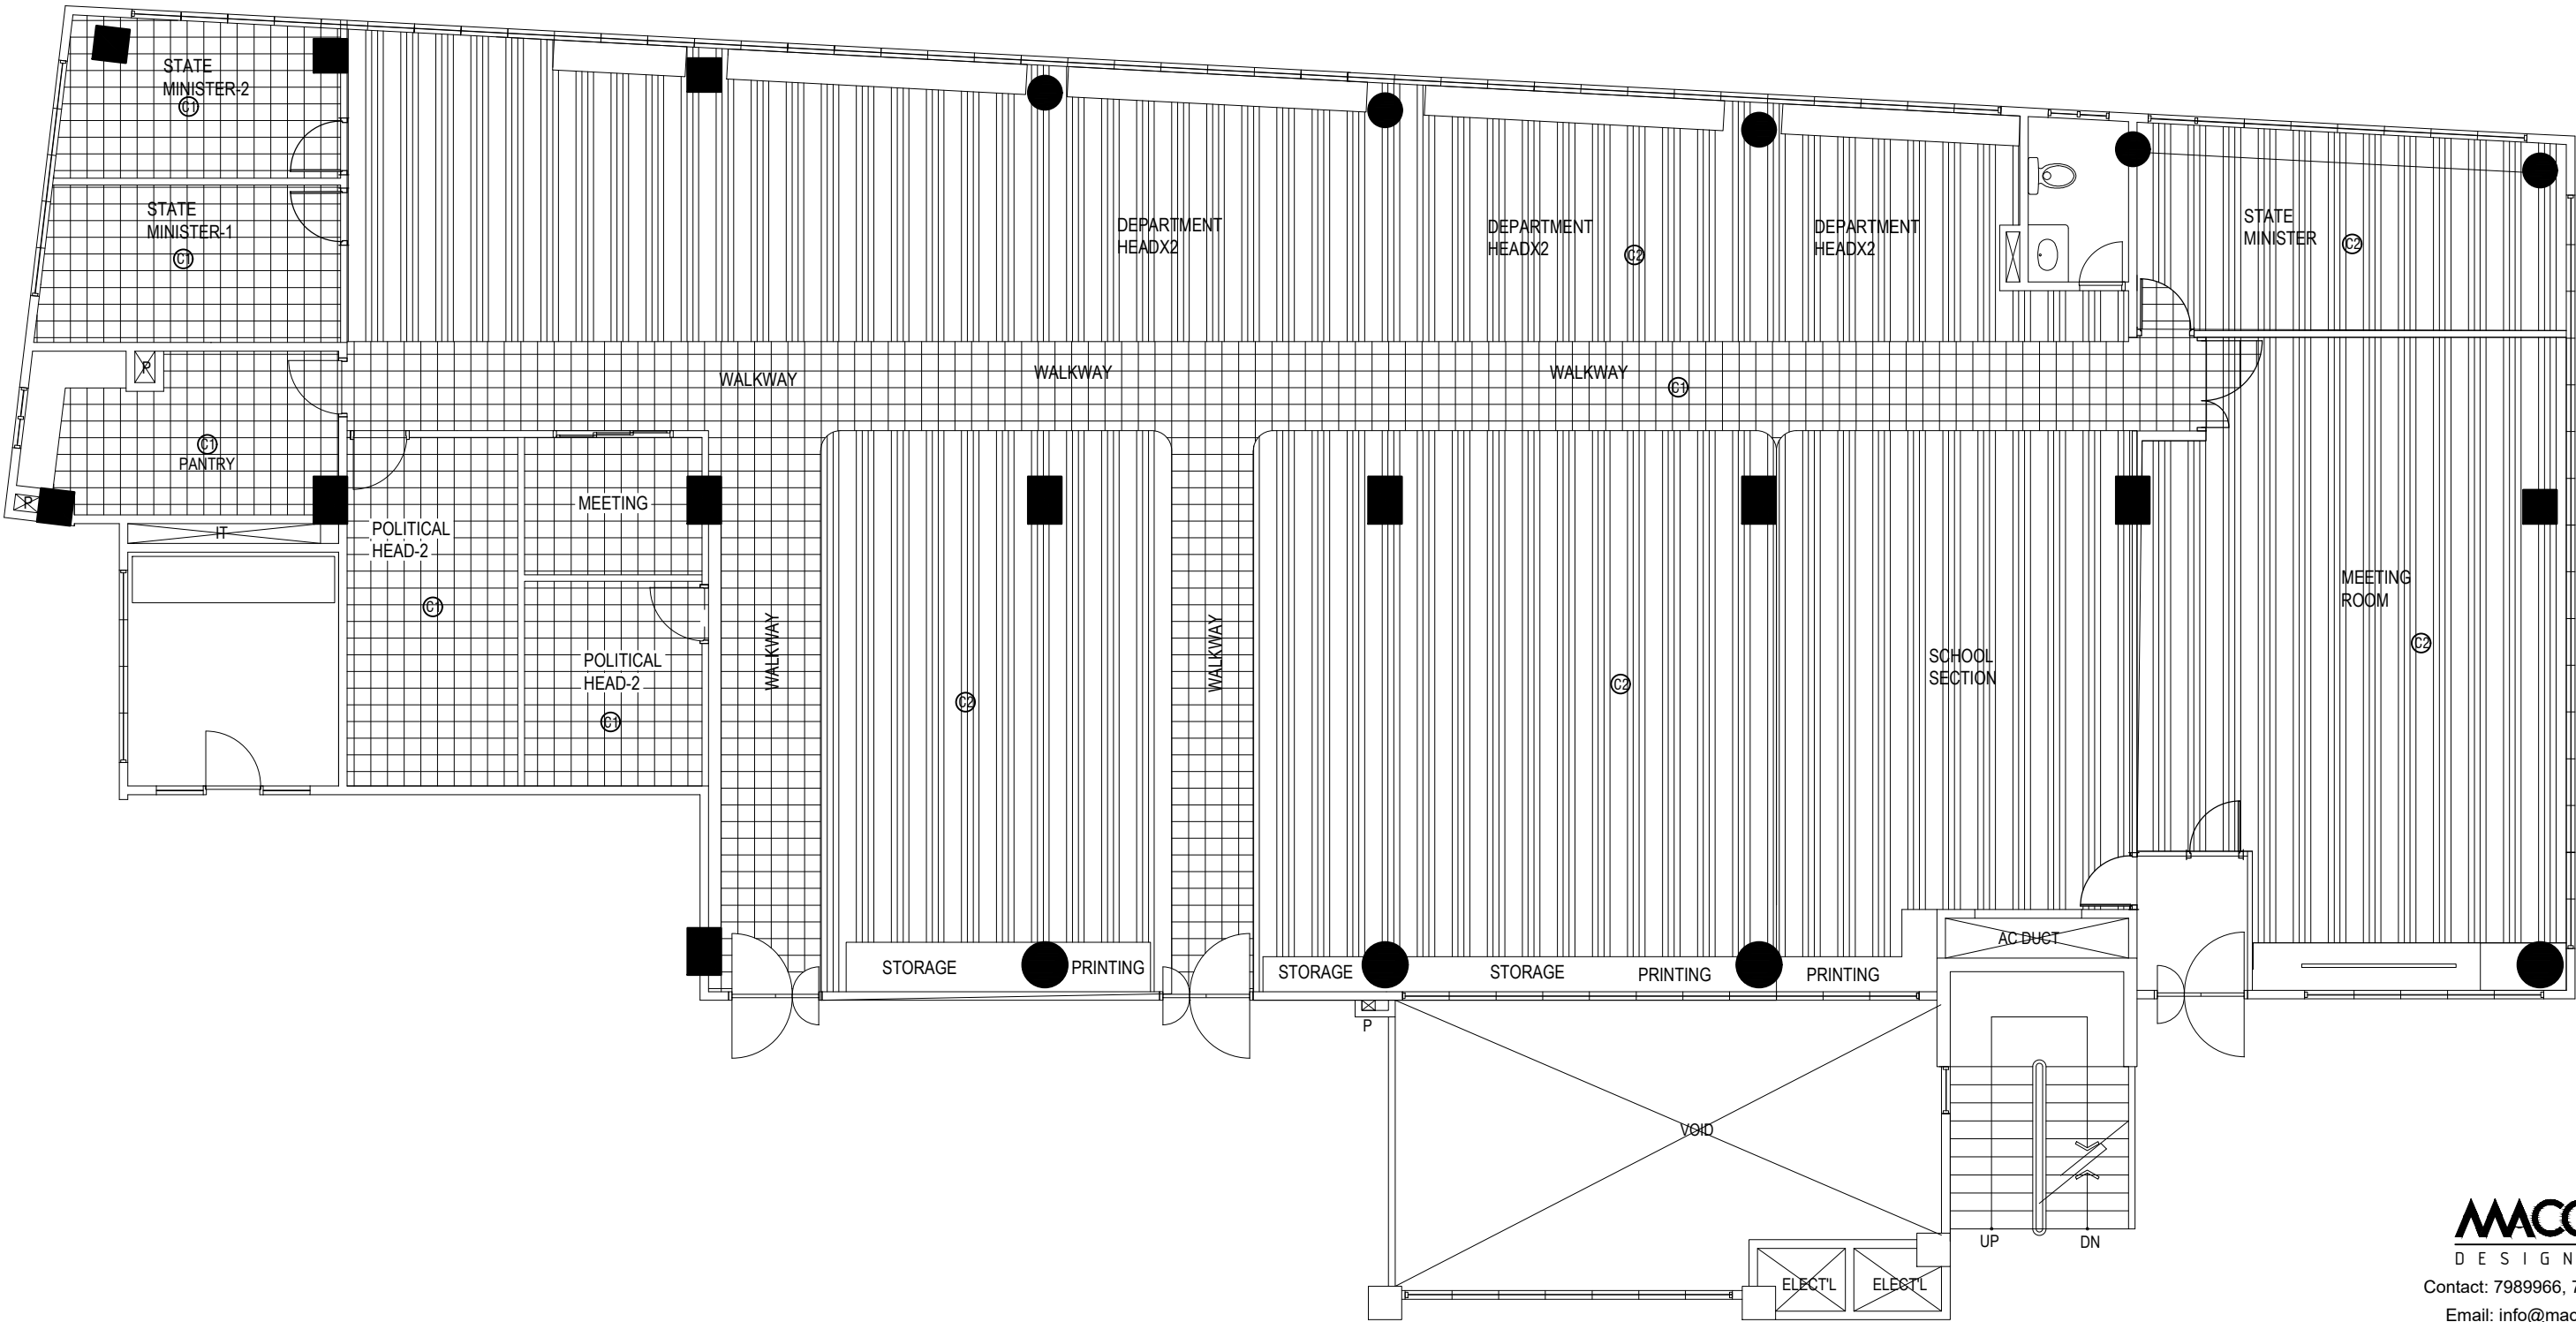

 FLOOR PLAN - FLOOR MATERIAL PLAN (CARPET)



MACO
DESIGNS

Contact: 7989966, 7691671


Email: info@maco.mv

C3




LEGEND	
HATCH	SPECIFICATION
	GLASS PARTITION WALL
	PARTITION WALL
	FROSTED GLASS PARTITION

HATCH	SPECIFICATION	FINISH	REF NUMBER
	WPC	WHITE FINISH	7.01
	WPC	WOOD FINISH	7.02
	WALL PAINT MATTE	BLUE COLOR	7.03
	CONCRETE WALL FINISH	TITANIUM CONCRETE FINISH SEMIGLOSS	7.04
NO HATCH	WALL PAINT MATTE	WHITE COLOR	7.05

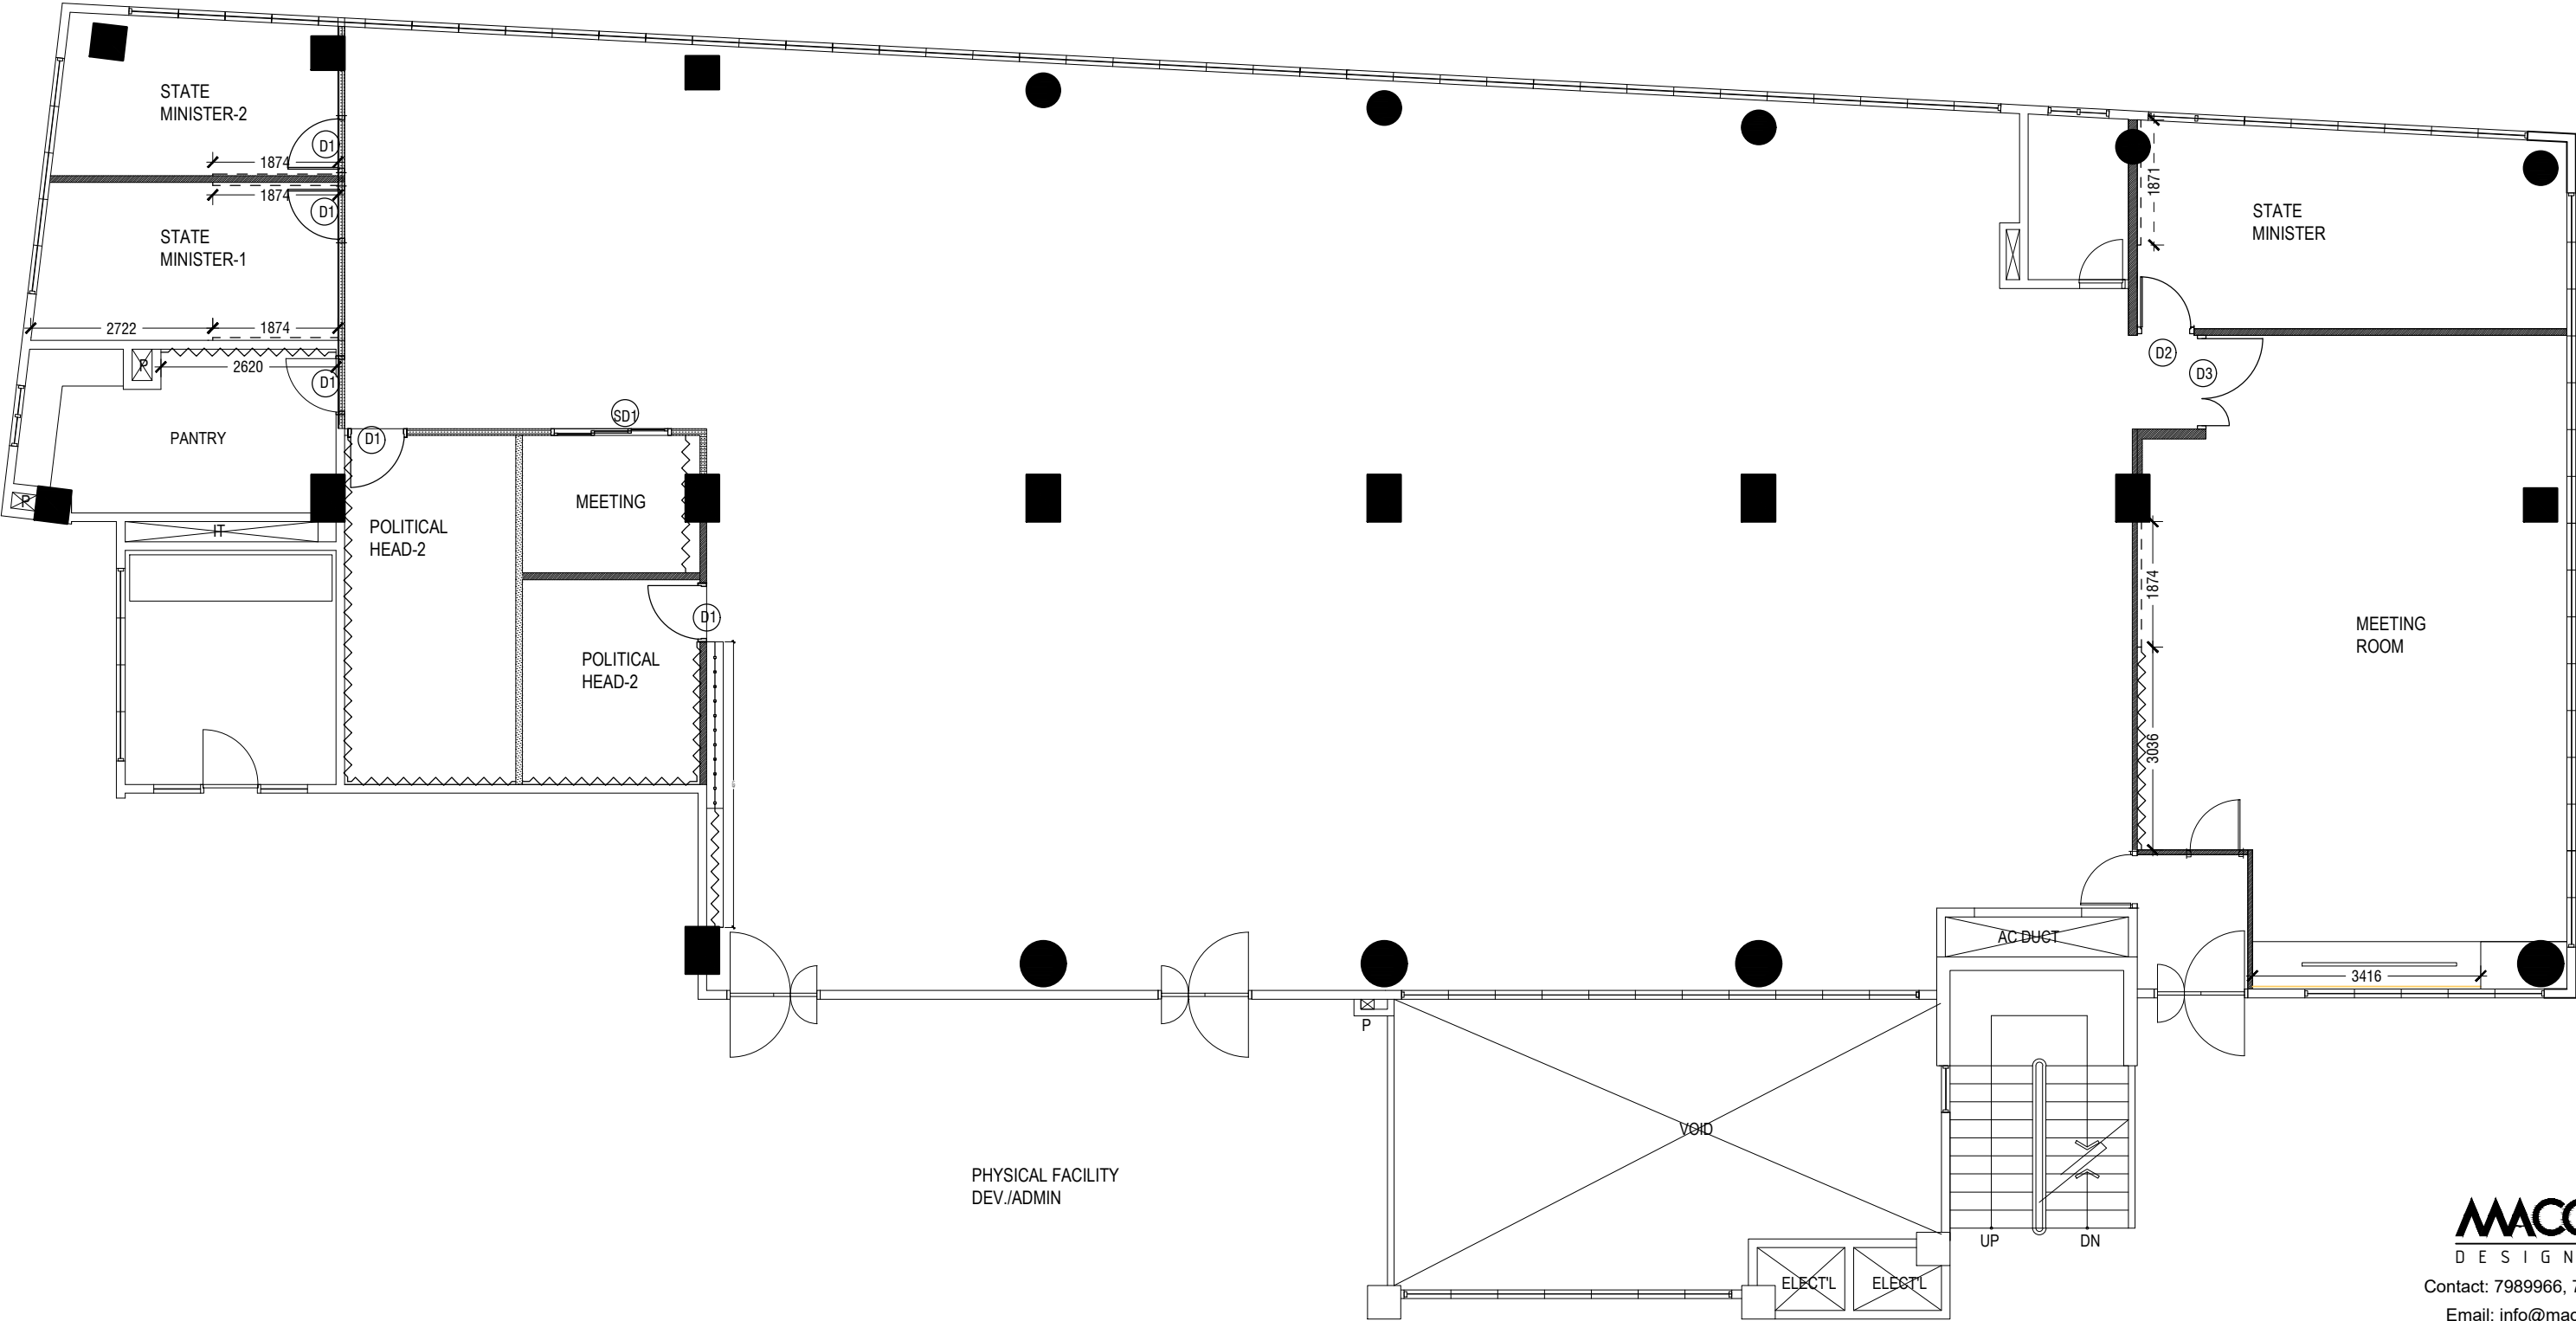


WALL FINISH PLAN

 


Contact: 7989966, 7691671

Email: info@maco.mv

C4

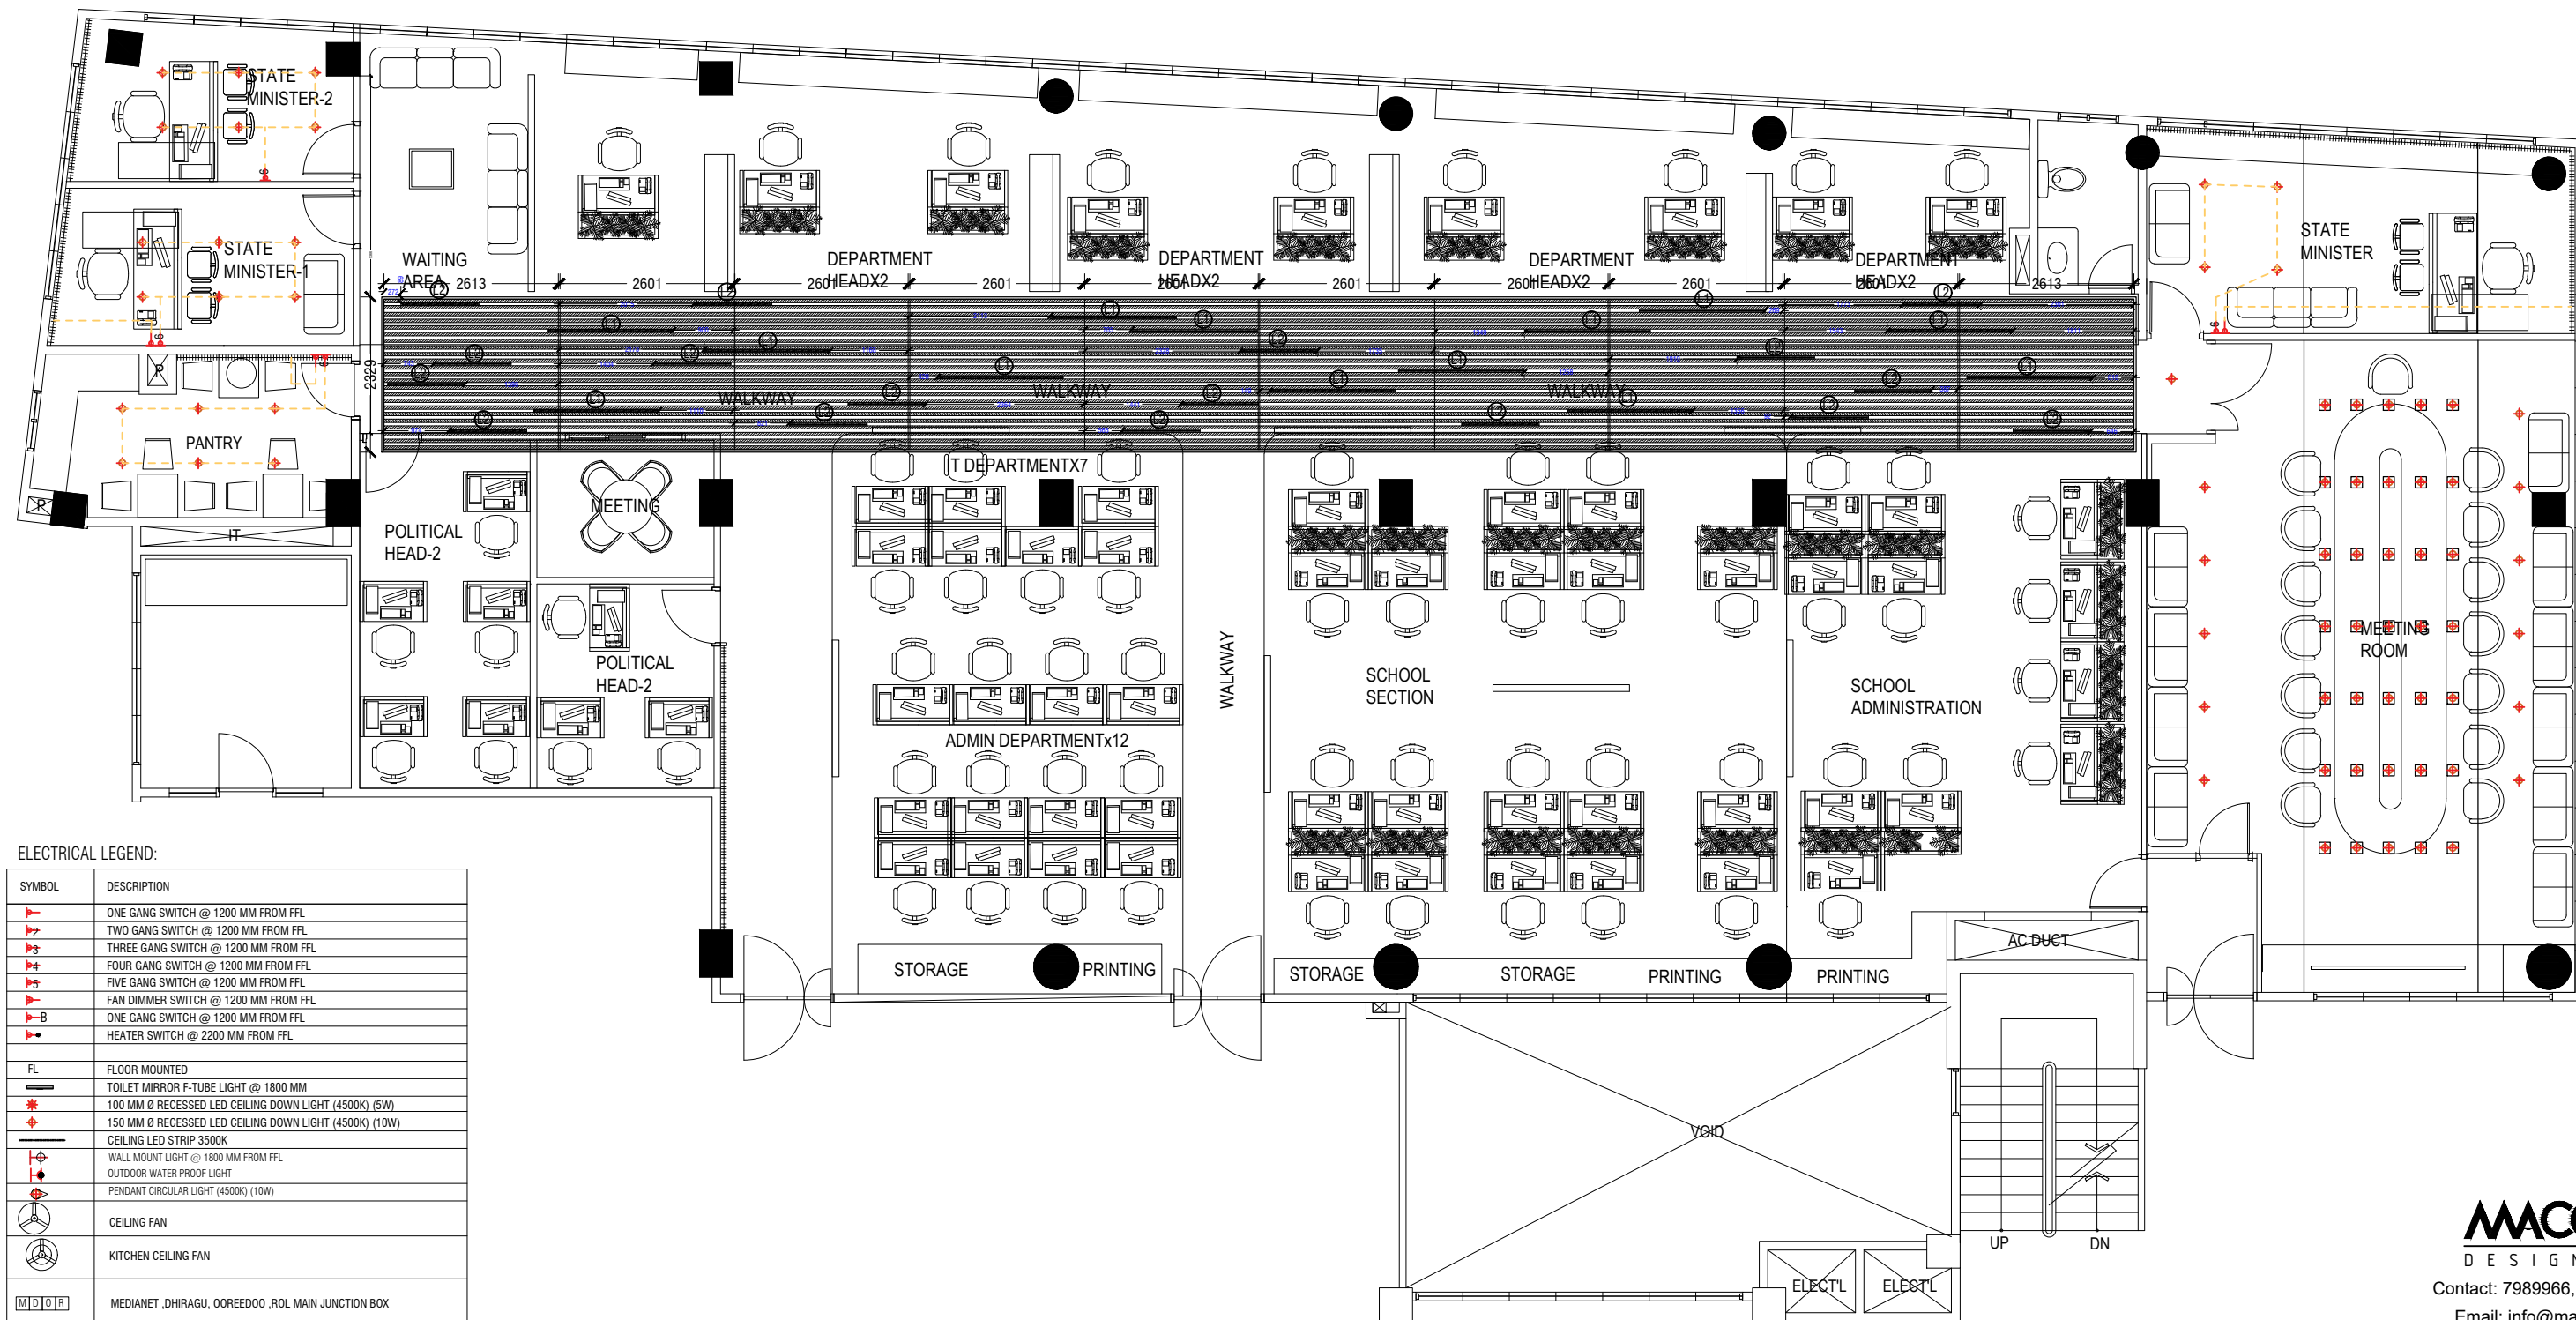

LIGHTNG PLAN

 

MACO
DESIGNS

Contact: 7989966, 7691671


Email: info@maco.mv

C5

POWER LEGEND:


SYMBOL	DESCRIPTION
	15 AMP SINGLE SOCKET @ 700 MM FROM FFL
	13 AMP DOUBLE SOCKET @ 700 MM FROM FFL
	13 AMP SOCKET @ 1200 MM FROM FFL
	13 AMP SOCKET @ 1000 MM FROM FFL
	13 AMP DOUBLE SOCKET @ 1200 MM FROM FFL
	15 AMP SOCKET @ 1800 MM FROM FFL
	13 AMP DOUBLE SOCKET @ 300 MM FROM FFL
	13 AMP DOUBLE SOCKET @ 500 MM FROM FFL
	13 AMP DOUBLE SOCKET FLOOR MOUNTED
	SHAVERS SOCKET @ 1300 MM FROM FFL (WEATHER PROOF)
	CABLE TV SOCKET OUTLET @ 300 MM FROM FFL
	FIBER SOCKET OUTLET @ 300 MM FROM FFL
	FIBER SOCKET OUTLET FLOOR MOUNTED
	AIR-CONDITIONER
	TABLE POWER PORTS

NOTE: DETAILED ELECTRICAL SYSTEM TO BE DESIGNED BY THE CONTRACTOR

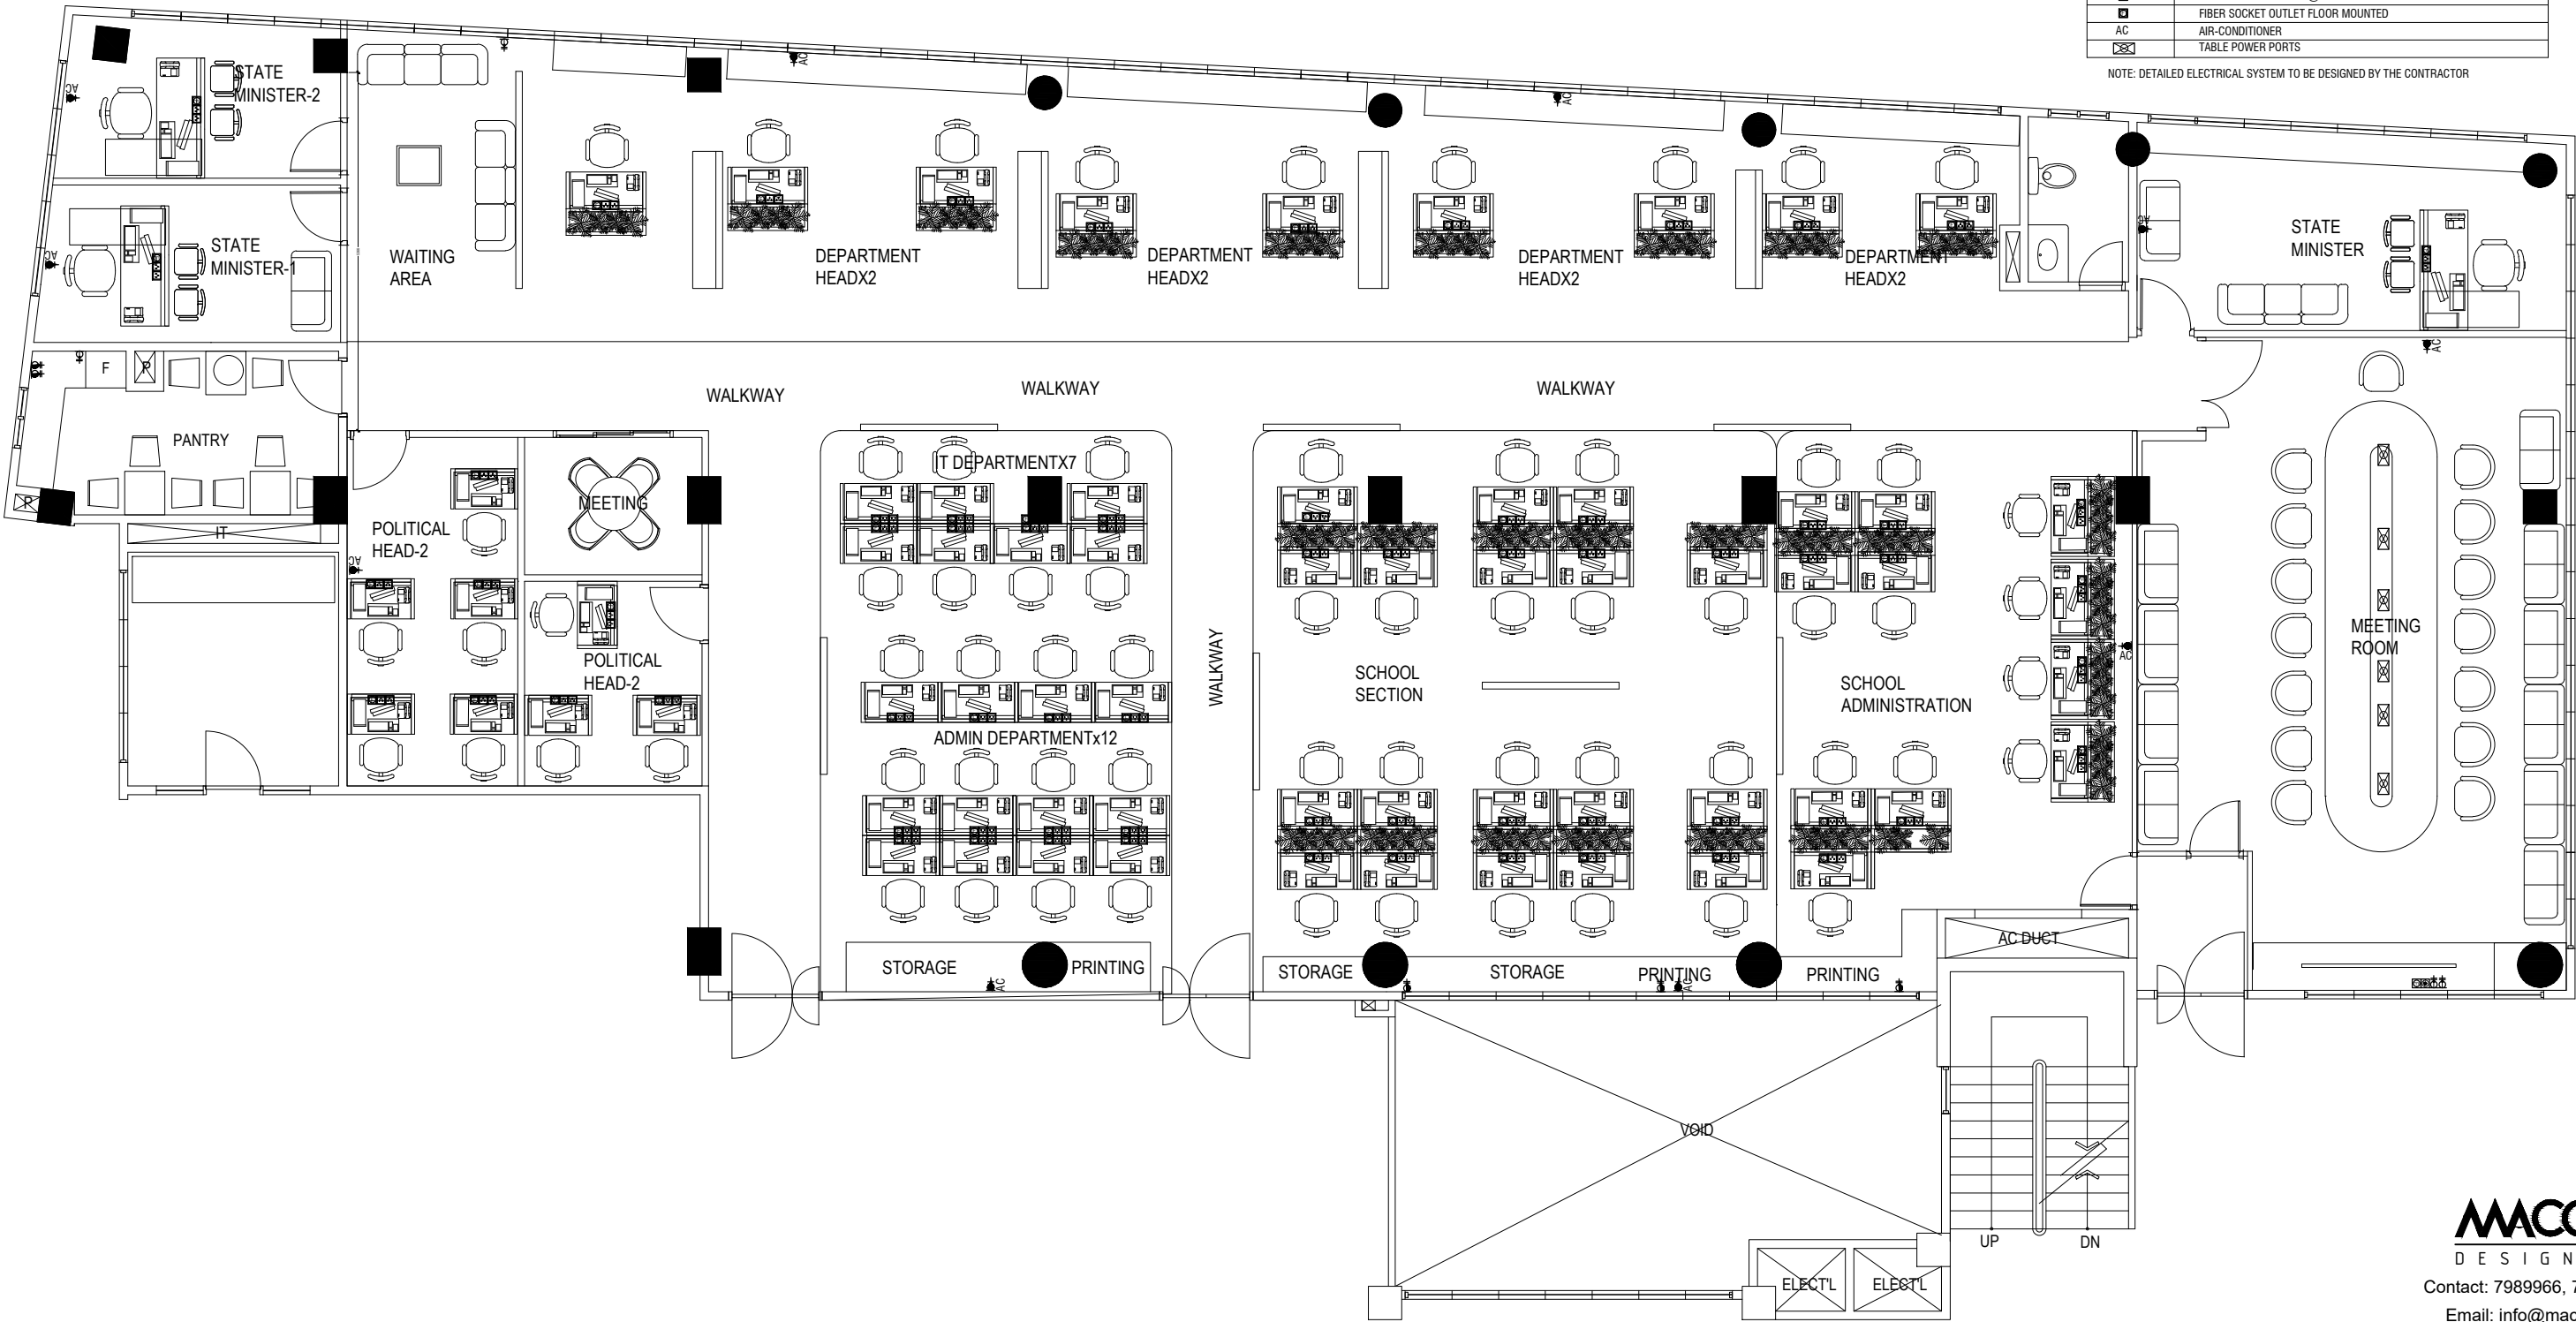

POWER PLAN

 SCALE = 1:100



MACO
DESIGNS





Contact: 7989966, 7691671





Email: info@maco.mv

C6




LEGEND			
SYMBOL	SPECIFICATION	SIZE	QTY
①	RECESSED LINEAR LED LIGHT		13
②	RECESSED LINEAR LED LIGHT		17

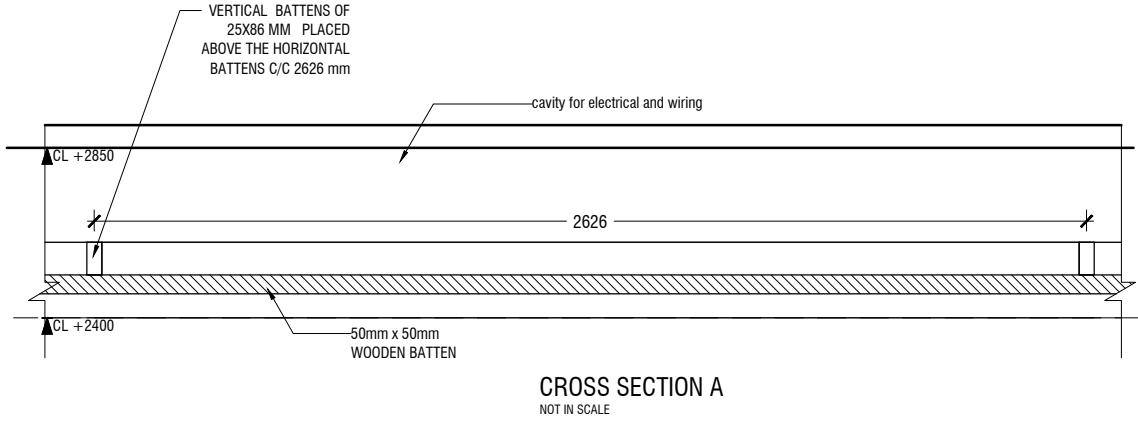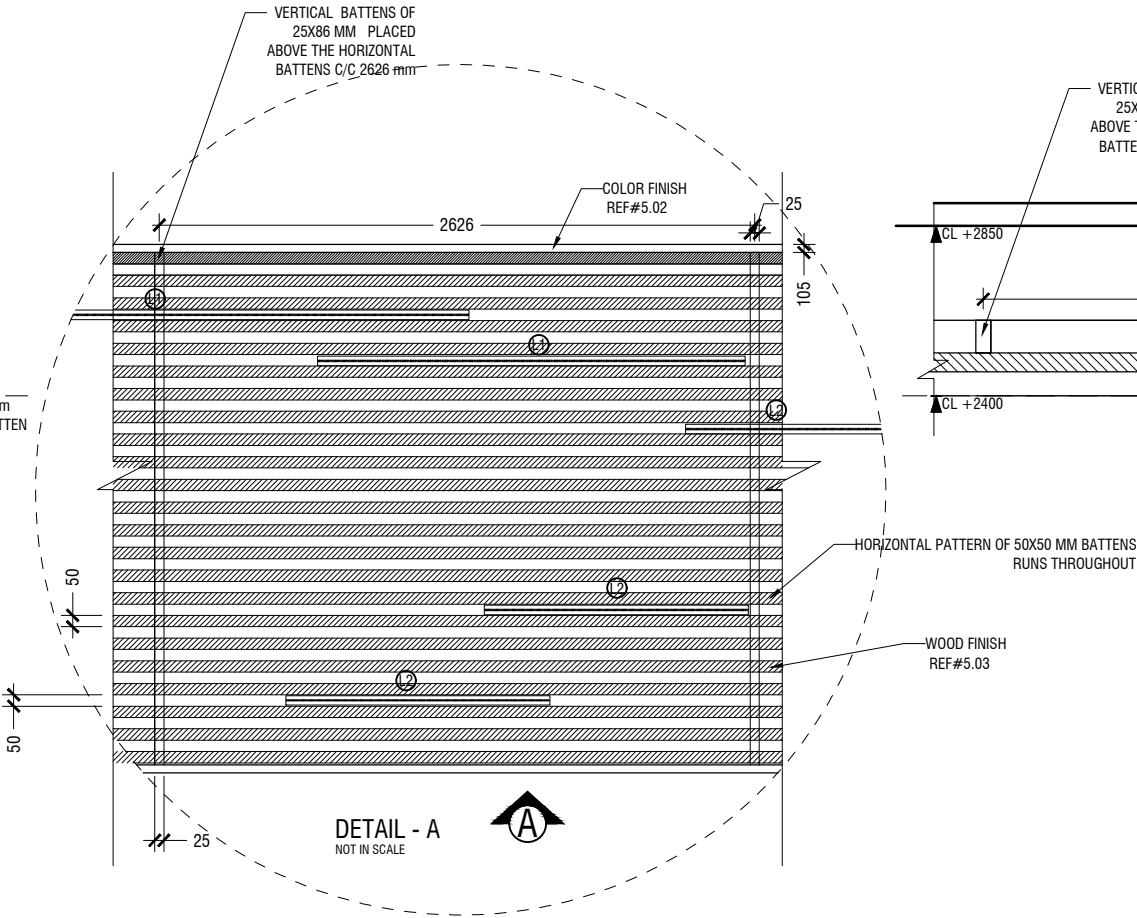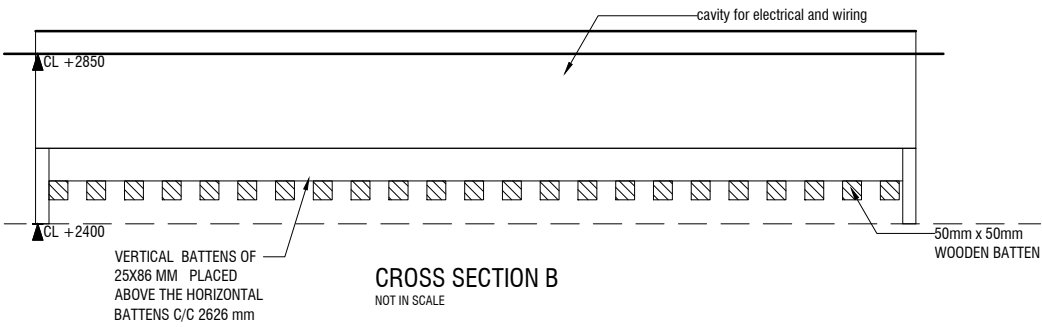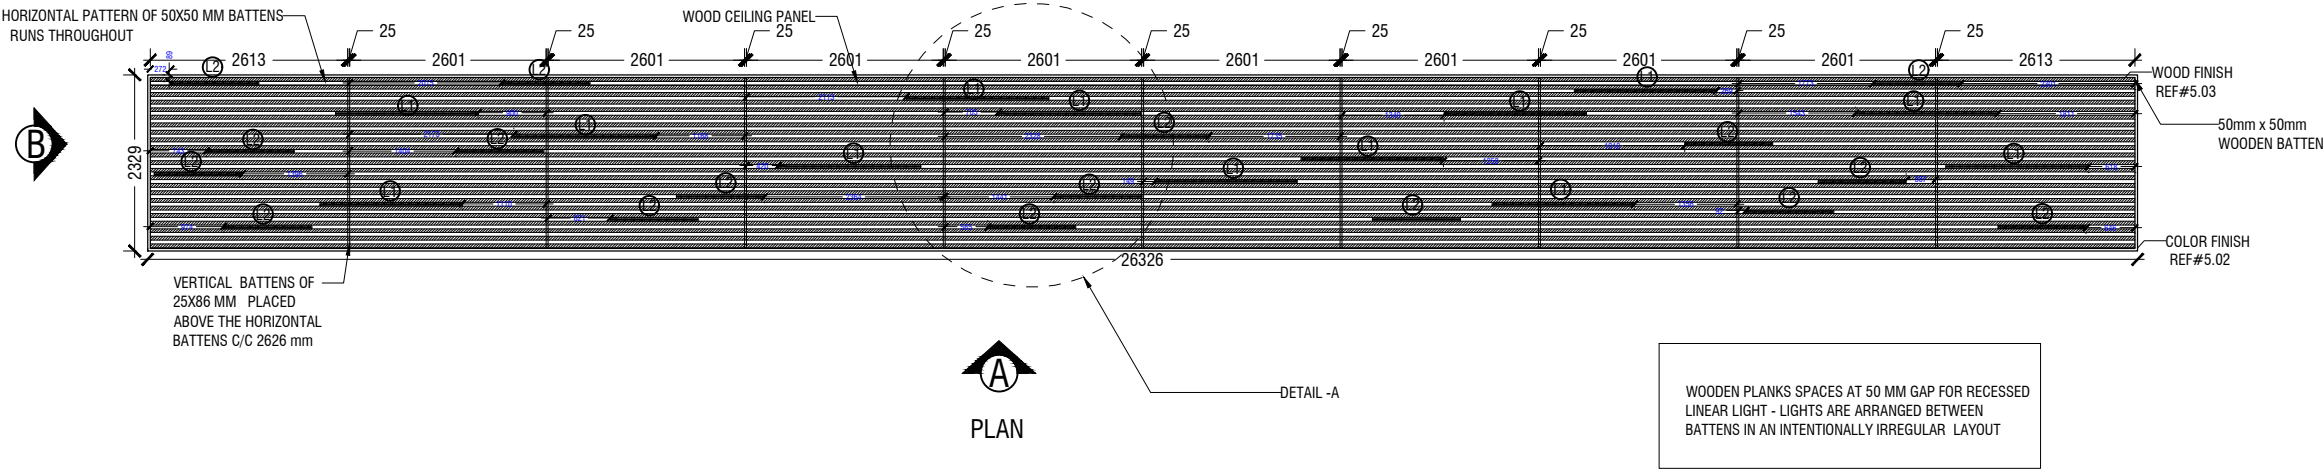

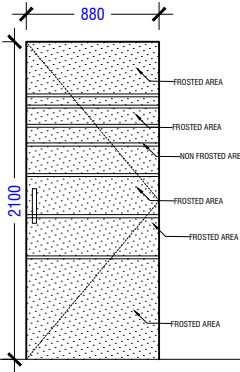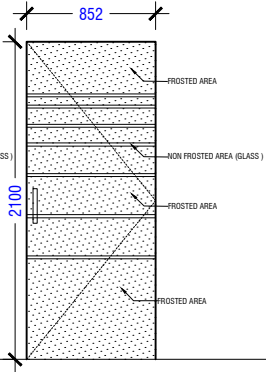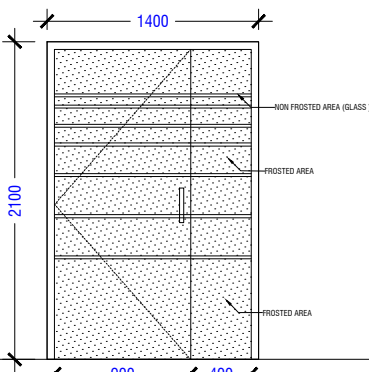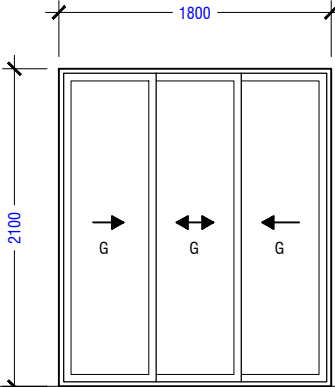DOOR LABEL	D1	D2	D3	SD1
NOTE: T-TIMBER G-GLASS TG-TEMPERED GLASS TL-TIMBER LOUVERED GL-GLASS LOUVERED AL-ALUMINIUM LOUVERED A-ALLUMINIUM PVC-PLASTIC S.S- STAINLESS STEEL FB-FIBER BOARD F.G-FROST GLASS				
FFL				
DESCRIPTION				SLIDING DOOR FRAME=A+PANEL=G IRONMONGERY = S.S

 DOOR WINDOW SCHEDULE



MACO
DESIGNS
Contact: 7989966, 7691671
Email: info@maco.mv

CLIENT:

MINISTRY OF
EDUCATION

PROJECT:

MINISTRY OF
EDUCATION

INTERIOR DESIGNER
NAAJID
HASSAN
FATHIMA

SCALE : AS GIVEN

DWNG TITLE : AS GIVN



D17M04Y25

WARNING:
- This drawing shall not be used for construction unless certified.
- Contractor to verify all dimensions of existing works on site before commencing any work or preparing shop drawings.
- Do not scale drawings, use written dimensions only.
- This drawing is to be read in conjunction with the specifications and conditions of contract.
- This drawing and design is copyright and no portion may be reproduced without the permission of the MACO architects

C8

- NOTE
- CL = CEILING LINE
 - DCL = DROP CEILING LINE
 - FFL = FLOOR FINISH LINE
 - RFL = RAISED FLOOR LINE
 - SFL = SUNKEN FLOOR LINE
 - BL = BEAM LEVEL

NO of pa x 7

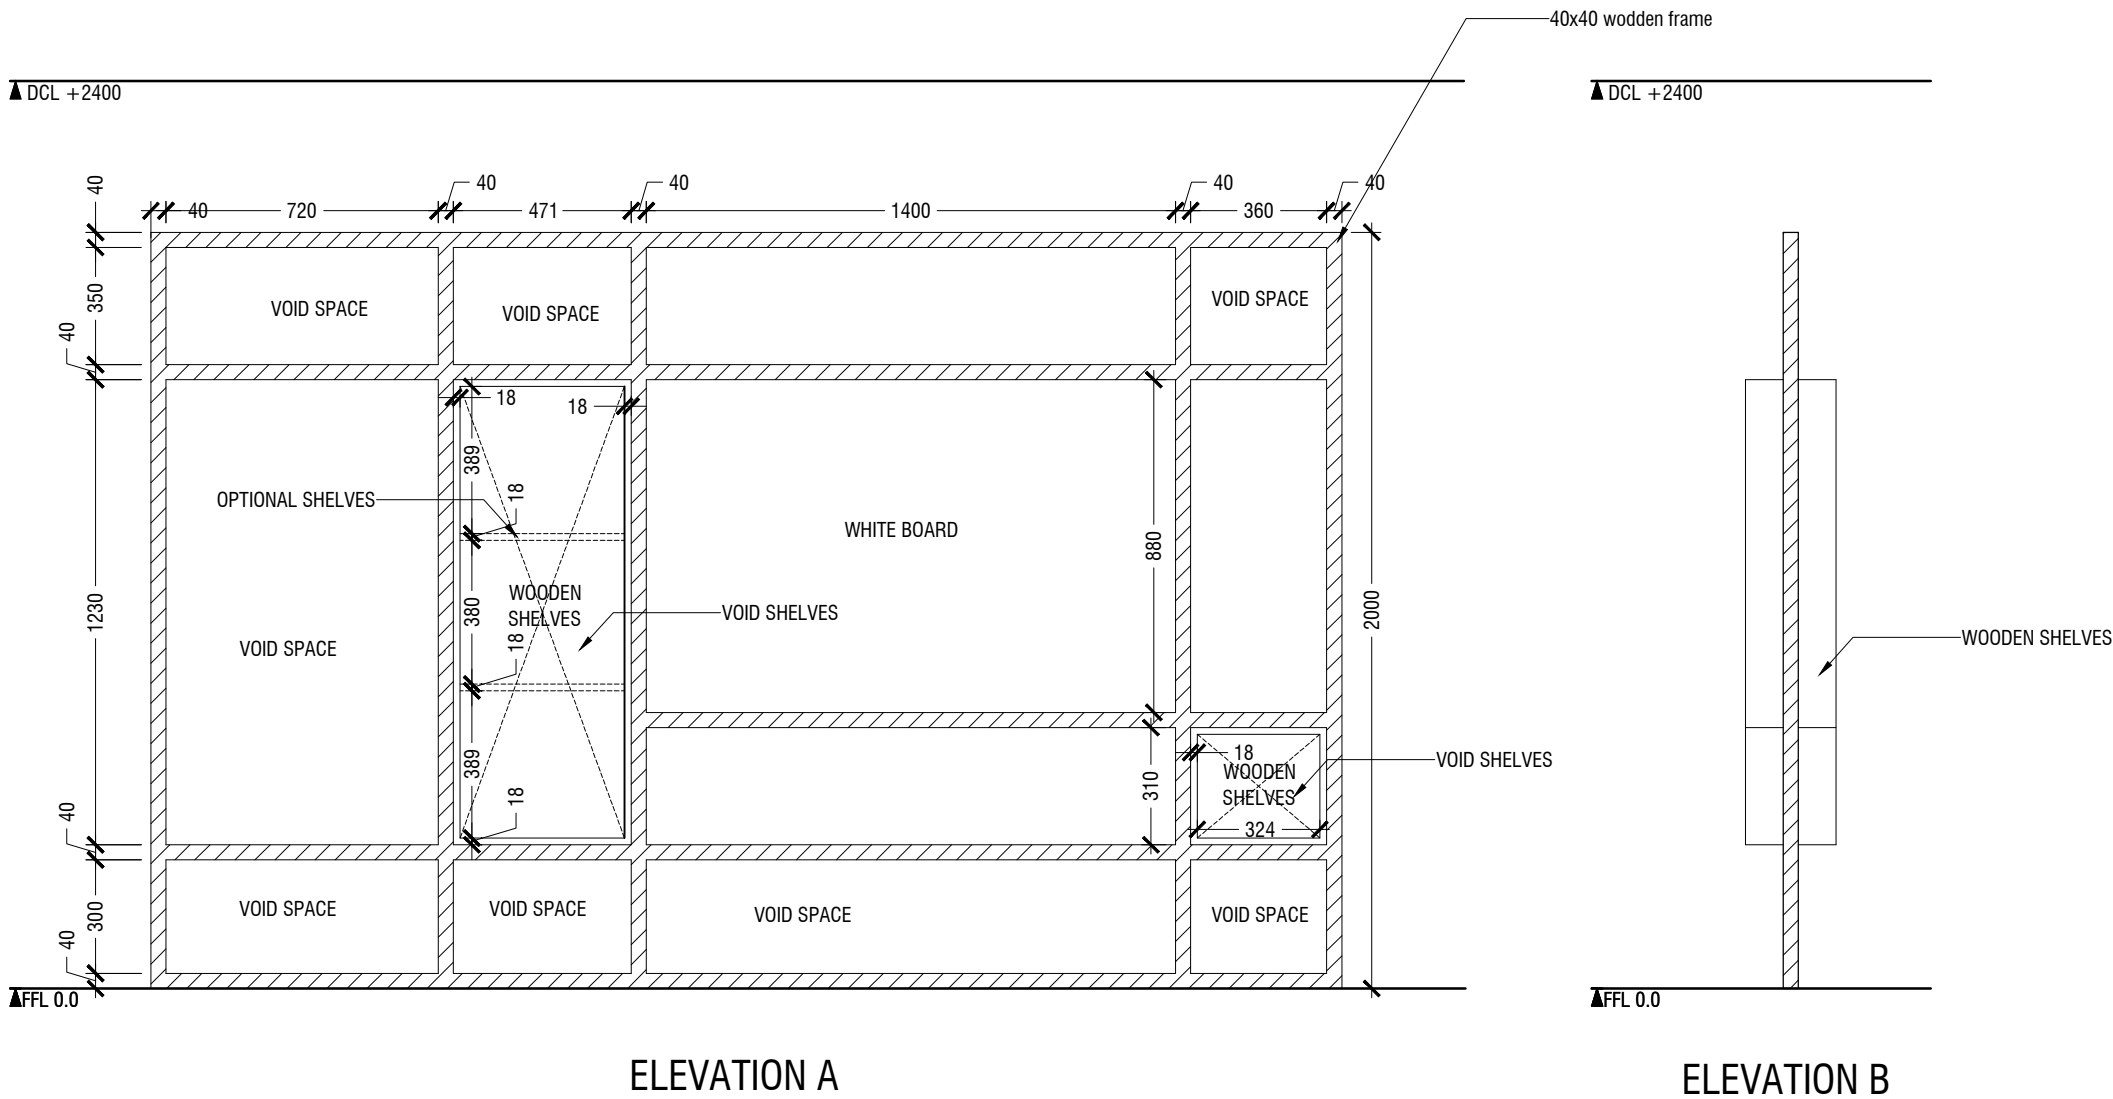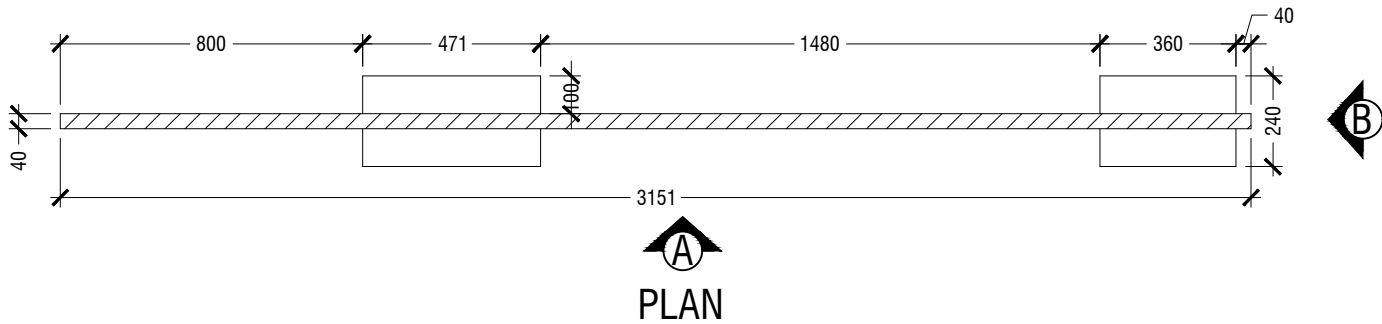

MACO
DESIGNS

Contact: 7989966, 7691671
Email: info@maco.mv

CLIENT:

MINISTRY OF
EDUCATION

PROJECT:

MINISTRY OF
EDUCATION

INTERIOR DESIGNER

NAAJID
HASSAN
FATHIMA

SCALE : AS GIVEN

DWNG TITLE : AS GIVN


D17M04Y25

WARNING:
- This drawing shall not be used for construction unless certified.
- Contractor to verify all dimensions of existing works on site before commencing any work or preparing shop drawings.
- Do not scale drawings, use written dimensions only.
- This drawing is to be read in conjunction with the specifications and conditions of contract.
- This drawing and design is copyright and no portion may be reproduced without the permission of the MACO architects

PERMIABLE DIVIDER
1.01 SCALE 1:20

ID01



- NOTE
- CL = CEILING LINE
 - DCL = DROP CEILING LINE
 - FFL = FLOOR FINISH LINE
 - RFL = RAISED FLOOR LINE
 - SFL = SUNKEN FLOOR LINE
 - BL = BEAM LEVEL

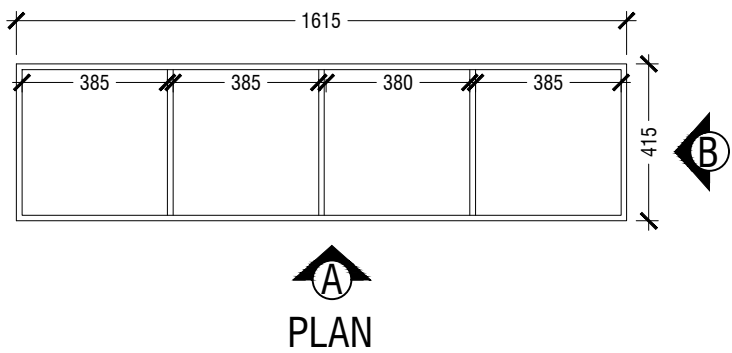

NO of pa x 4

▲ DCL +2400

▲ DCL +2400

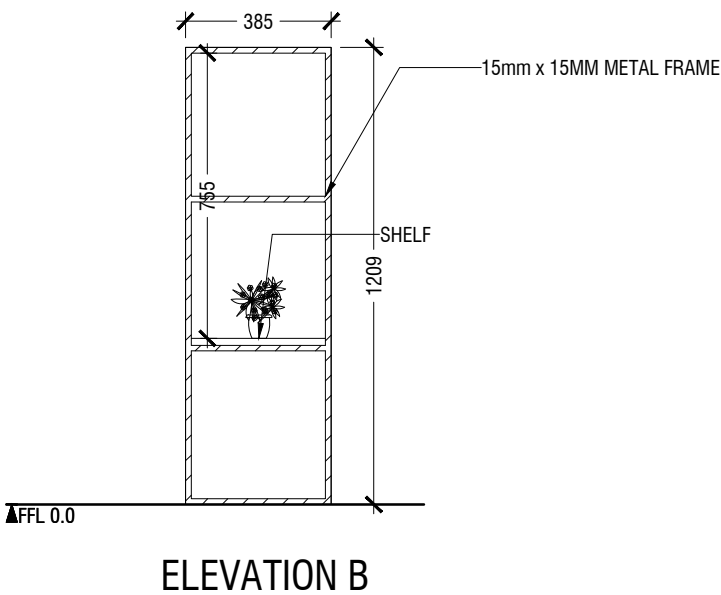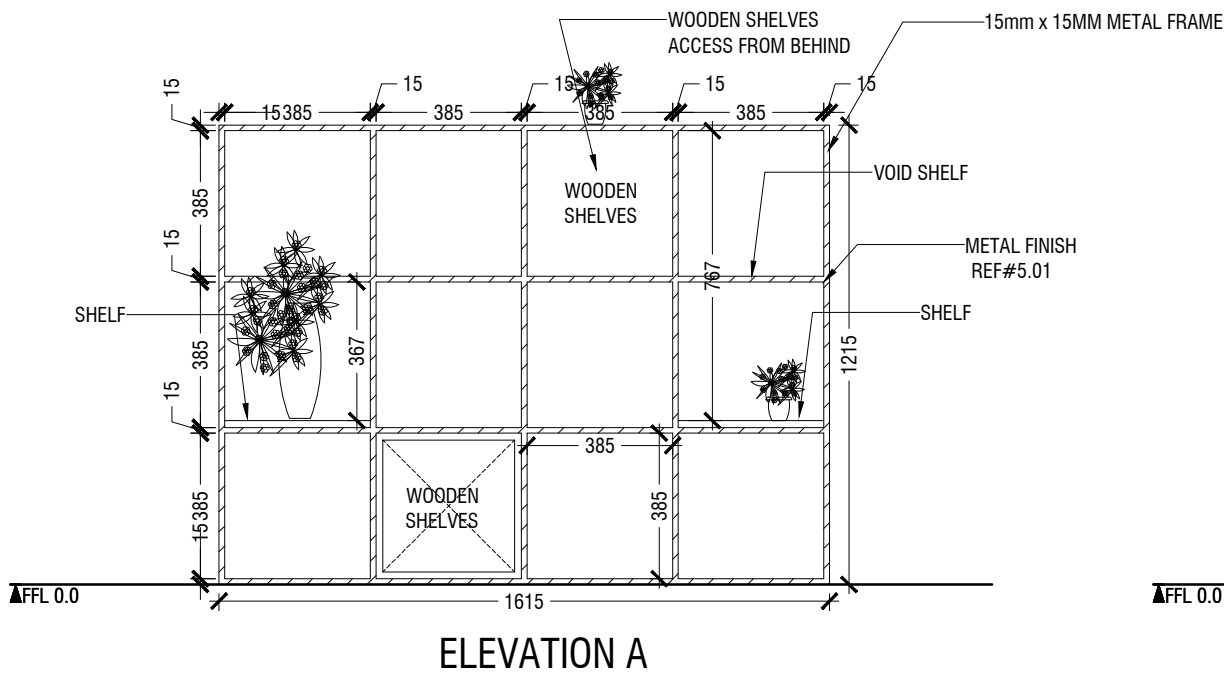

MACO
DESIGNS

Contact: 7989966, 7691671
Email: info@maco.mv

CLIENT:

MINISTRY OF
EDUCATION

PROJECT:

MINISTRY OF
EDUCATION

INTERIOR DESIGNER

NAAJID
HASSAN
FATHIMA


SCALE : AS GIVEN

DWNG TITLE : AS GIVN

D17M04Y25

WARNING:
- This drawing shall not be used for construction unless certified.
- Contractor to verify all dimensions of existing works on site before commencing any work or preparing shop drawings.
- Do not scale drawings, use written dimensions only.
- This drawing is to be read in conjunction with the specifications and conditions of contract.
- This drawing and design is copyright and no portion may be reproduced without the permission of the MACO architects



- NOTE
- CL = CEILING LINE
 - DCL = DROP CEILING LINE
 - FFL = FLOOR FINISH LINE
 - RFL = RAISED FLOOR LINE
 - SFL = SUNKEN FLOOR LINE
 - BL = BEAM LEVEL

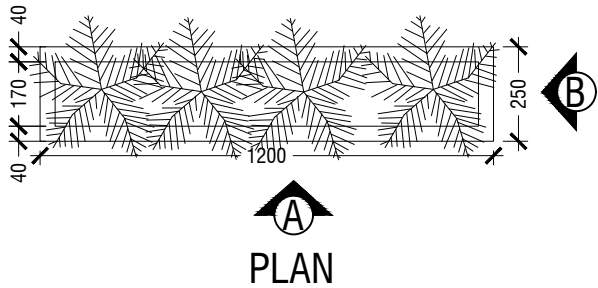

NO OF PLANTER BOX : 31

▲ DCL +2400

▲ DCL +2400

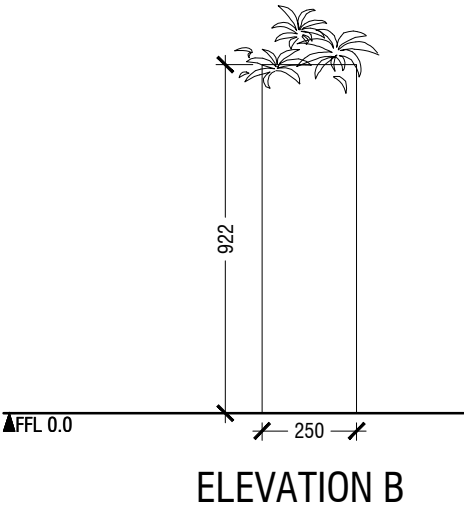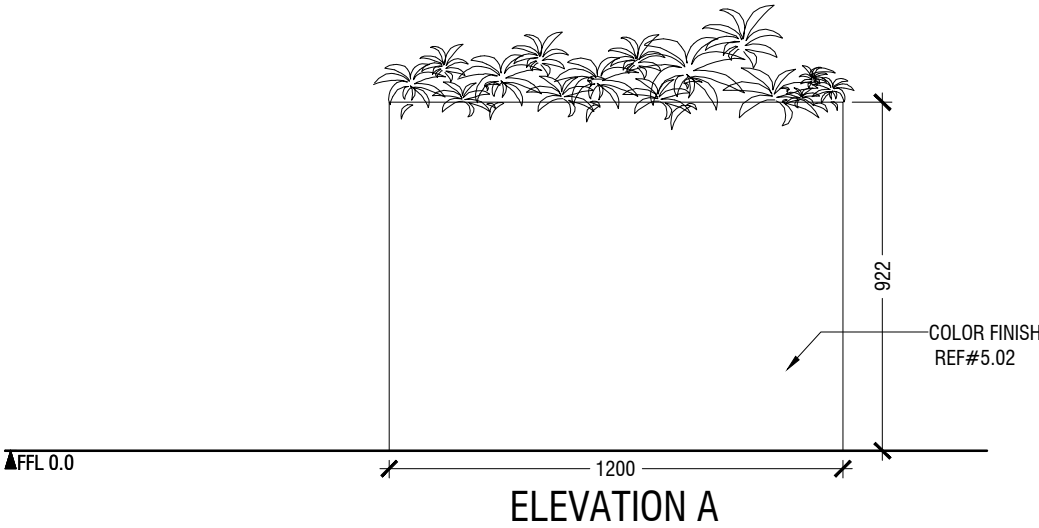

MACO
DESIGNS

Contact: 7989966, 7691671

Email: info@maco.mv

CLIENT:

MINISTRY OF
EDUCATION

PROJECT:

MINISTRY OF
EDUCATION

INTERIOR DESIGNER

NAAJID
HASSAN
FATHIMA

SCALE : AS GIVEN

DWNG TITLE : AS GIVN


D17M04Y25

WARNING:
- This drawing shall not be used for construction unless certified.
- Contractor to verify all dimensions of existing works on site before commencing any work or preparing shop drawings.
- Do not scale drawings, use written dimensions only.
- This drawing is to be read in conjunction with the specifications and conditions of contract.
- This drawing and design is copyright and no portion may be reproduced without the permission of the MACO architects

1.03 PLANTER BOX
SCALE 1:20

ID03



- NOTE
- CL = CEILING LINE
 - DCL = DROP CEILING LINE
 - FFL = FLOOR FINISH LINE
 - RFL = RAISED FLOOR LINE
 - SFL = SUNKEN FLOOR LINE
 - BL = BEAM LEVEL

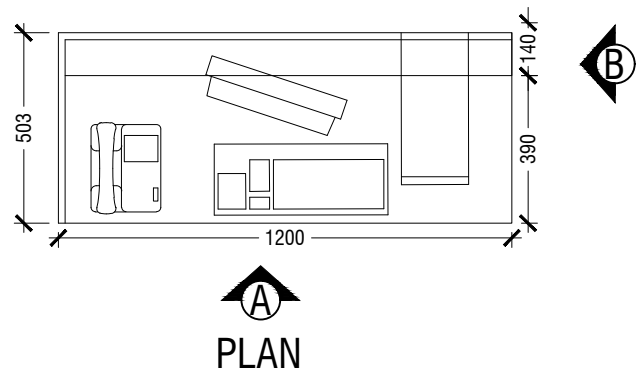

NO OF TABLES : 57

▲ DCL +2400

▲ DCL +2400

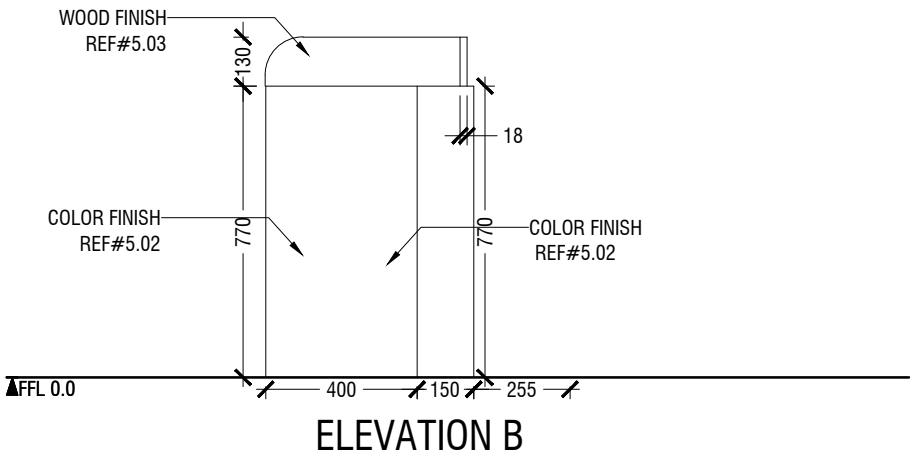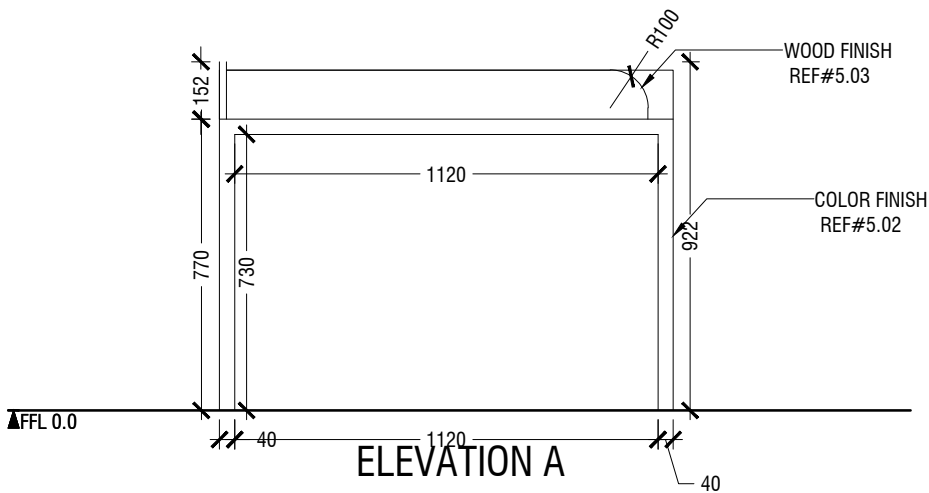

MACO
DESIGNS

Contact: 7989966, 7691671
Email: info@maco.mv

CLIENT:

MINISTRY OF
EDUCATION

PROJECT:

MINISTRY OF
EDUCATION

INTERIOR DESIGNER

NAAJID
HASSAN
FATHIMA

SCALE : AS GIVEN

DWNG TITLE : AS GIVN


D17M04Y25

WARNING:
- This drawing shall not be used for construction unless certified.
- Contractor to verify all dimensions of existing works on site before commencing any work or preparing shop drawings.
- Do not scale drawings, use written dimensions only.
- This drawing is to be read in conjunction with the specifications and conditions of contract.
- This drawing and design is copyright and no portion may be reproduced without the permission of the MACO architects

TABLE
1.04 SCALE 1:20

ID04

- NOTE
- CL = CEILING LINE
 - DCL = DROP CEILING LINE
 - FFL = FLOOR FINISH LINE
 - RFL = RAISED FLOOR LINE
 - SFL = SUNKEN FLOOR LINE
 - BL = BEAM LEVEL



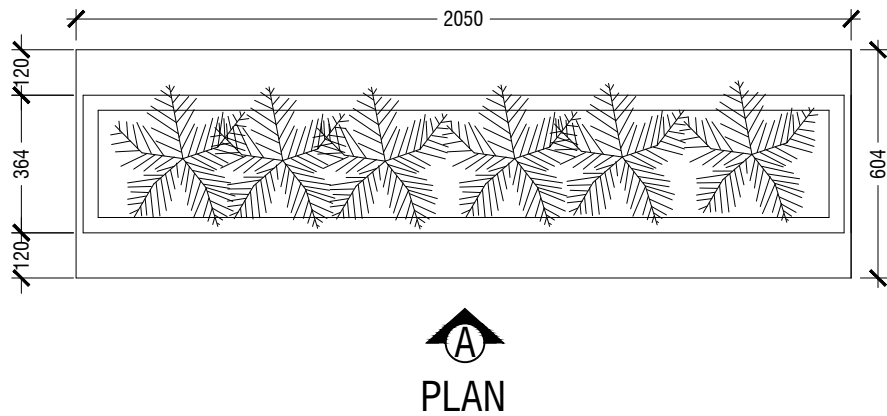


NO OF TABLES : 12

▲ DCL +2400

▲ DCL +2400

▲ DCL +2400

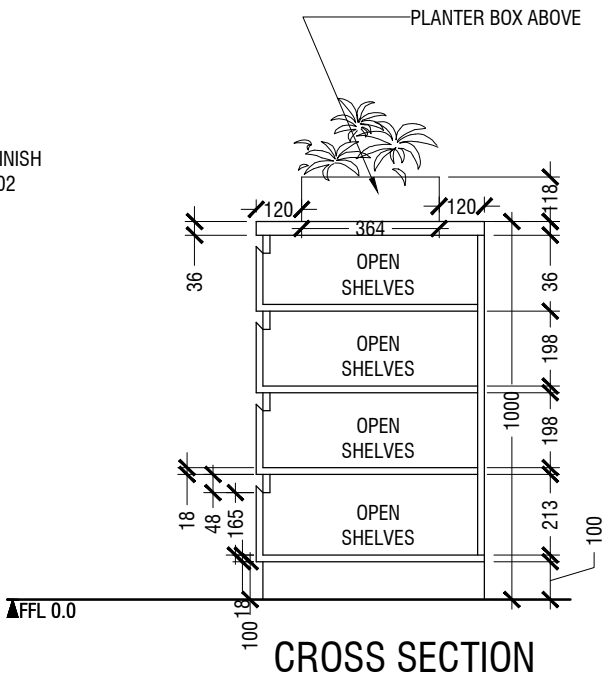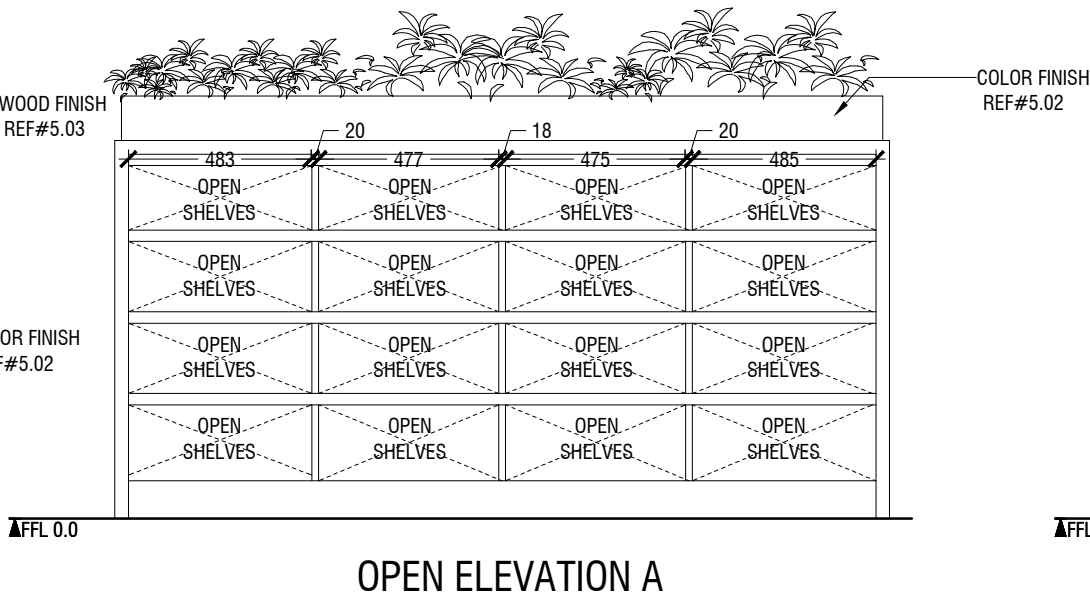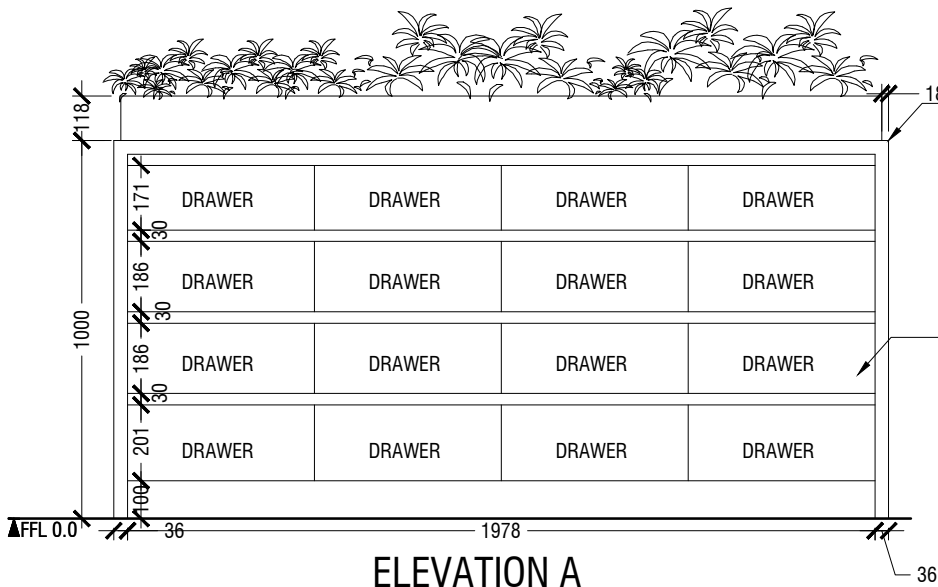

MACO
DESIGNS

Contact: 7989966, 7691671

Email: info@maco.mv

CLIENT:

MINISTRY OF
EDUCATION

PROJECT:

MINISTRY OF
EDUCATION

INTERIOR DESIGNER

NAAJID
HASSAN
FATHIMA

SCALE : AS GIVEN

DWNG TITLE : AS GIVN



D17M04Y25

WARNING:
- This drawing shall not be used for construction unless certified.
- Contractor to verify all dimensions of existing works on site before commencing any work or preparing shop drawings.
- Do not scale drawings, use written dimensions only.
- This drawing is to be read in conjunction with the specifications and conditions of contract.
- This drawing and design is copyright and no portion may be reproduced without the permission of the MACO architects


1.05 PLANTER ABOVE STORAGE BELOW
SCALE 1:20

ID05


- NOTE
- CL = CEILING LINE
 - DCL = DROP CEILING LINE
 - FFL = FLOOR FINISH LINE
 - RFL = RAISED FLOOR LINE
 - SFL = SUNKEN FLOOR LINE
 - BL = BEAM LEVEL

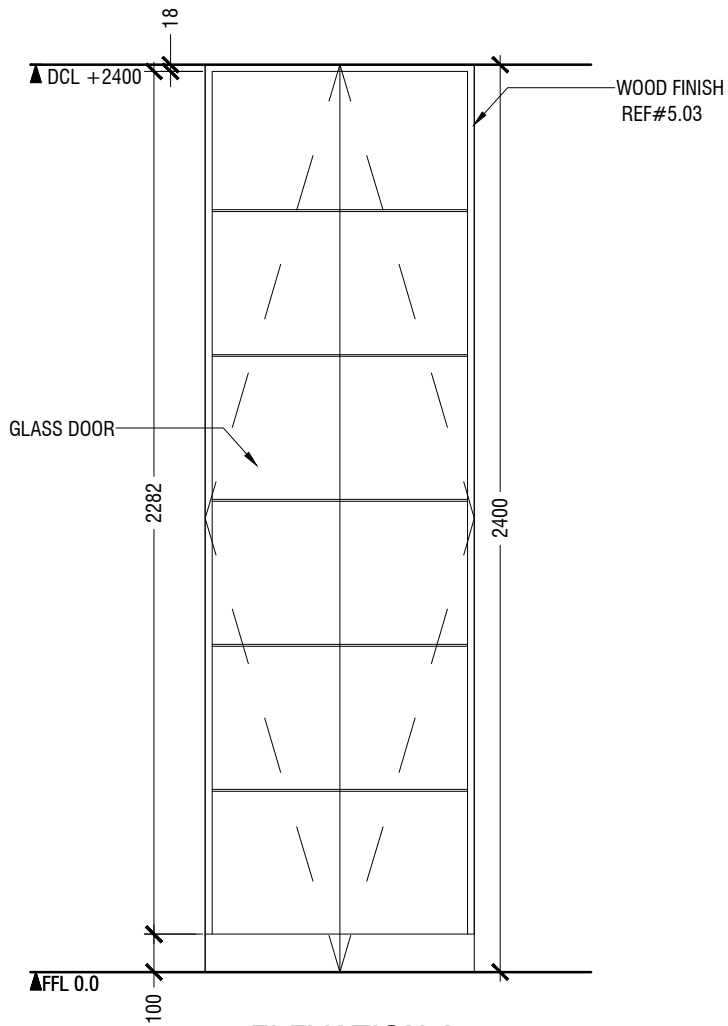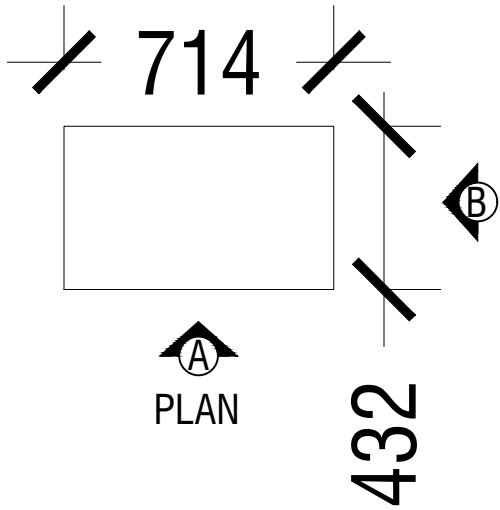


ELEVATION A

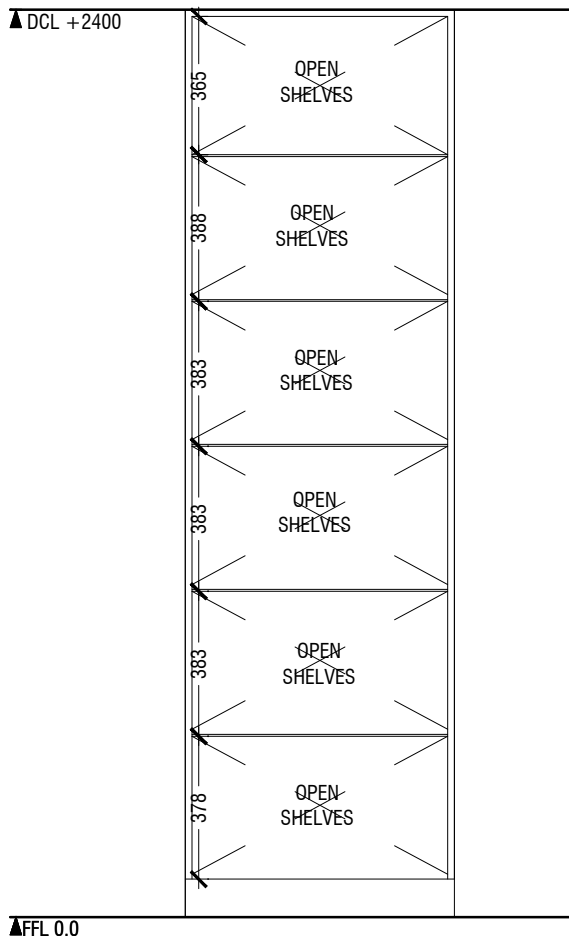

OPEN ELEVATION A

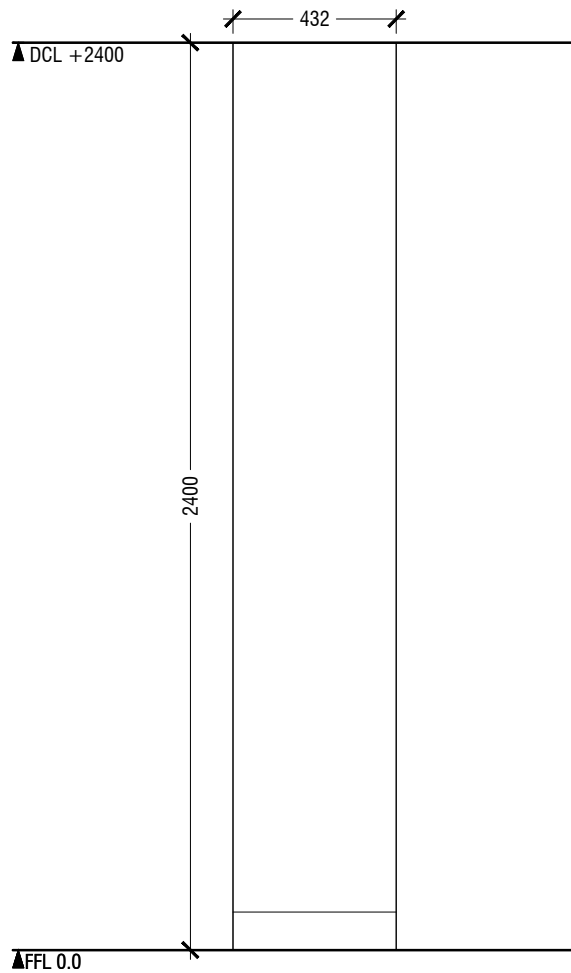

ELEVATION B

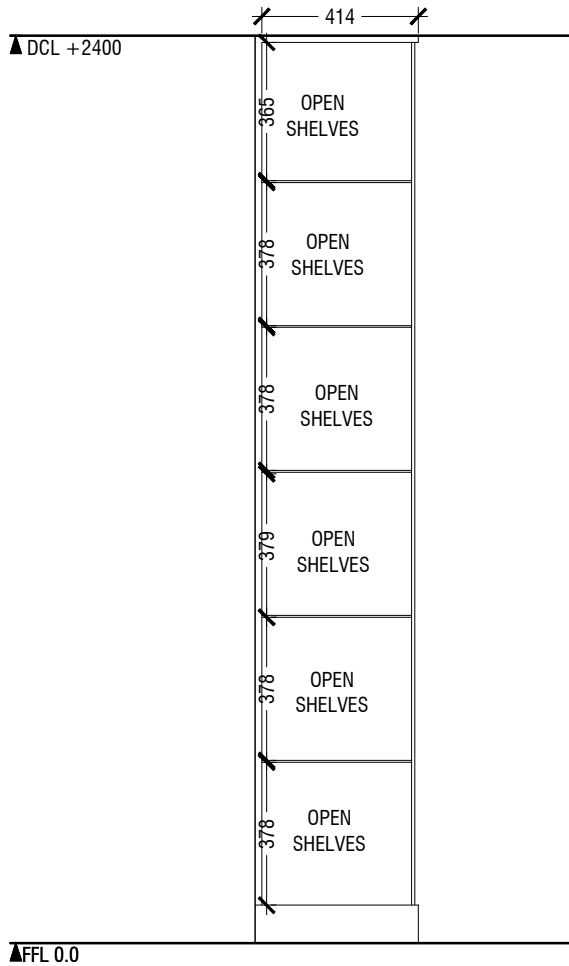

CROSS SECTION

MACO
DESIGNS

Contact: 7989966, 7691671
Email: info@maco.mv

CLIENT:

MINISTRY OF
EDUCATION

PROJECT:

MINISTRY OF
EDUCATION

INTERIOR DESIGNER

NAAJID
HASSAN
FATHIMA

SCALE : AS GIVEN

DWNG TITLE : AS GIVN


D17M04Y25

WARNING:
- This drawing shall not be used for construction unless certified.
- Contractor to verify all dimensions of existing works on site before commencing any work or preparing shop drawings.
- Do not scale drawings, use written dimensions only.
- This drawing is to be read in conjunction with the specifications and conditions of contract.
- This drawing and design is copyright and no portion may be reproduced without the permission of the MACO architects



ID06

1.06 CUPBOARD
LOCATION "STATE MINISTER -1 "
SCALE 1:20

- NOTE
- CL = CEILING LINE
 - DCL = DROP CEILING LINE
 - FFL = FLOOR FINISH LINE
 - RFL = RAISED FLOOR LINE
 - SFL = SUNKEN FLOOR LINE
 - BL = BEAM LEVEL



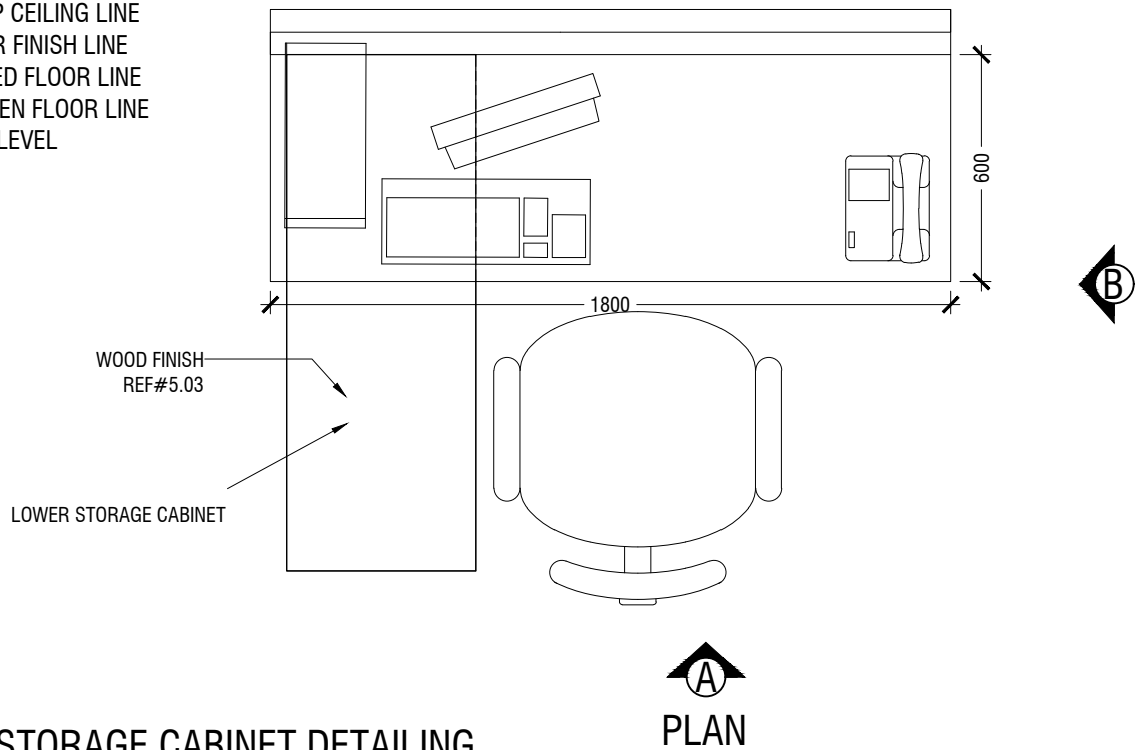


LOWER STORAGE CABINET DETAILING

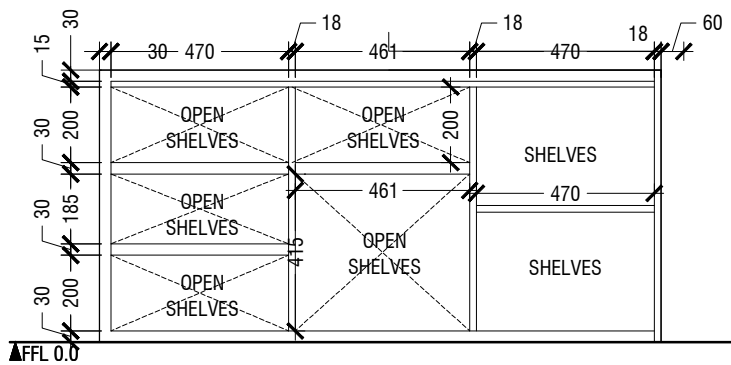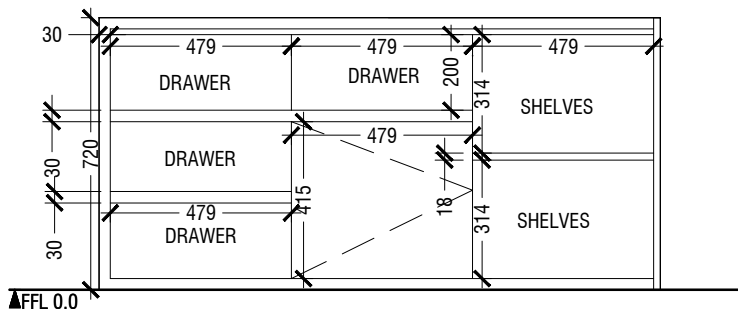

OPEN ELEVATION B

NO of pa x3

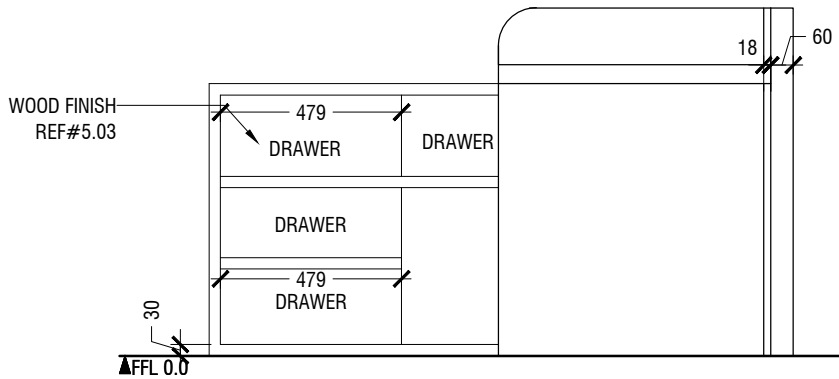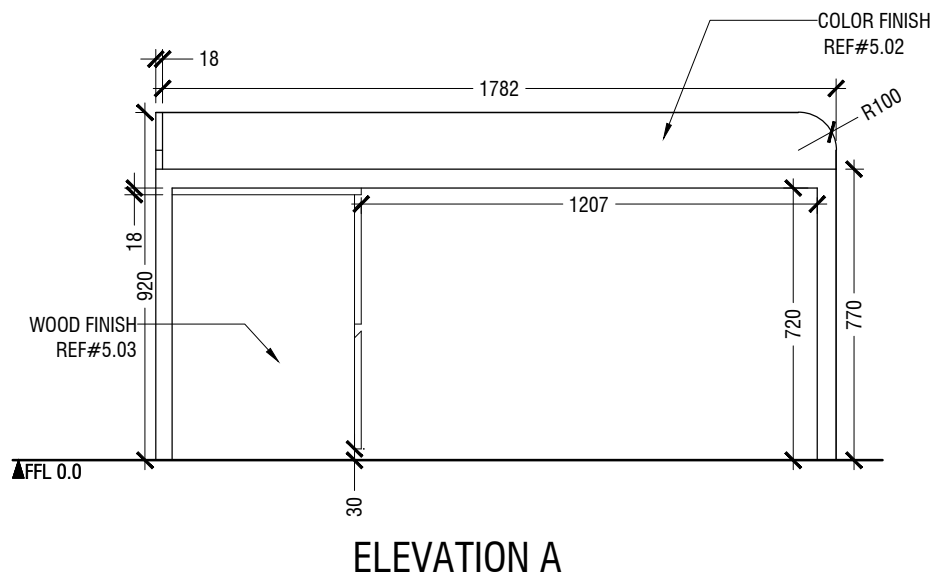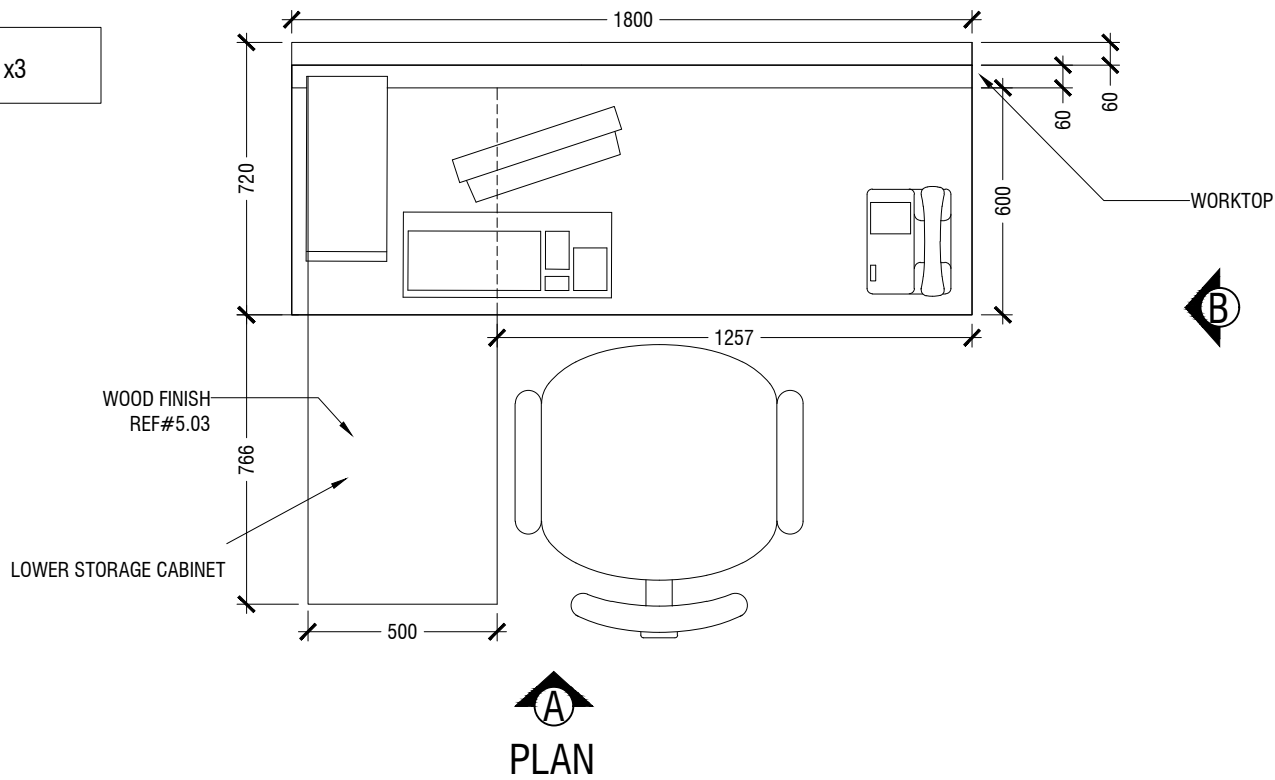

ELEVATION B

MACO
DESIGNS

Contact: 7989966, 7691671

Email: info@maco.mv

CLIENT:

MINISTRY OF
EDUCATION

PROJECT:

MINISTRY OF
EDUCATION

INTERIOR DESIGNER

NAAJID
HASSAN
FATHIMA

SCALE : AS GIVEN


DWNG TITLE : AS GIVN

D17M04Y25


WARNING:
- This drawing shall not be used for construction unless certified.
- Contractor to verify all dimensions of existing works on site before commencing any work or preparing shop drawings.
- Do not scale drawings, use written dimensions only.
- This drawing is to be read in conjunction with the specifications and conditions of contract.
- This drawing and design is copyright and no portion may be reproduced without the permission of the MACO architects

ID07

- NOTE
- CL = CEILING LINE
 - DCL = DROP CEILING LINE
 - FFL = FLOOR FINISH LINE
 - RFL = RAISED FLOOR LINE
 - SFL = SUNKEN FLOOR LINE
 - BL = BEAM LEVEL

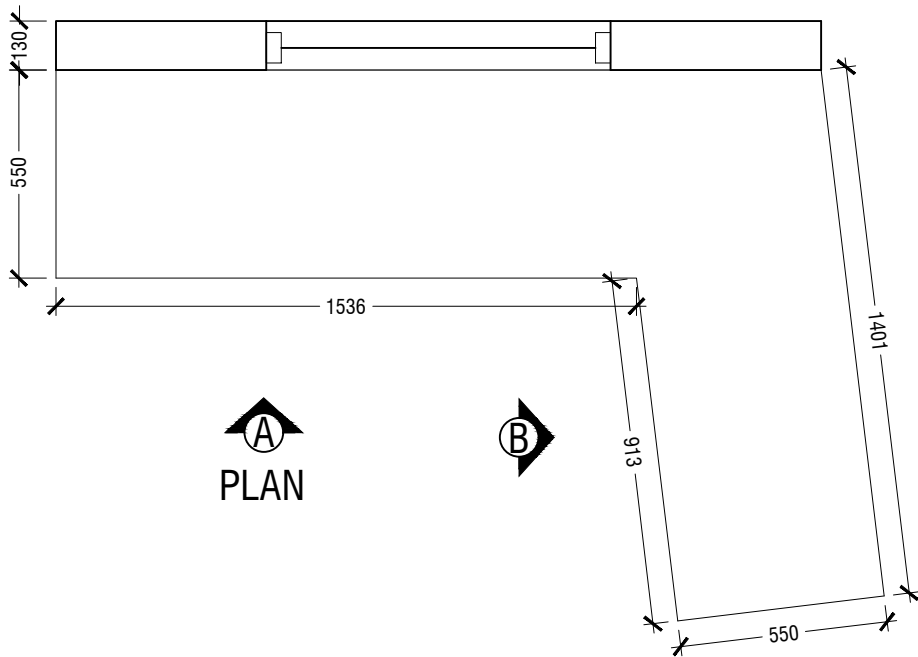

▲ DCL +2400 ▲ DCL +2400 ▲ DCL +2400 ▲ DCL +2400 ▲ DCL +2400

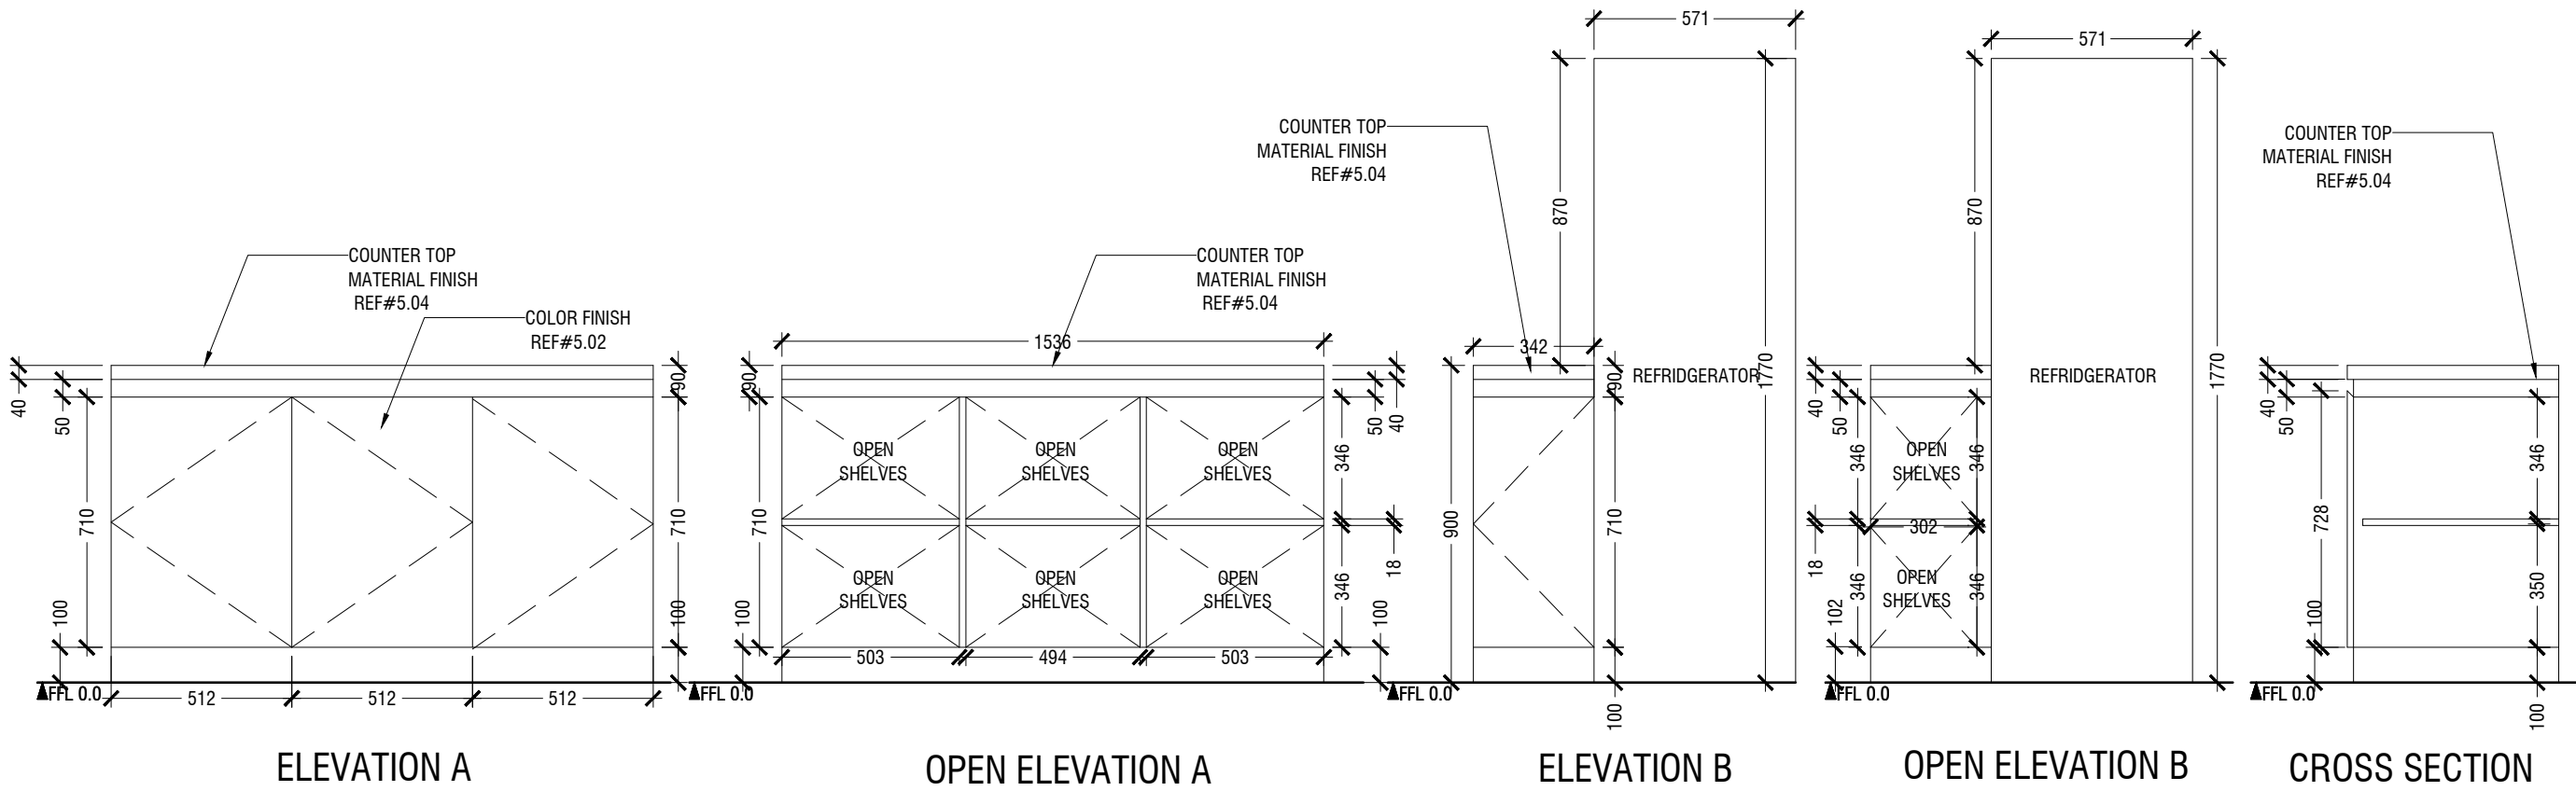

MACO
DESIGNS

Contact: 7989966, 7691671

Email: info@maco.mv

CLIENT:

MINISTRY OF
EDUCATION

PROJECT:

MINISTRY OF
EDUCATION

INTERIOR DESIGNER

NAAJID
HASSAN
FATHIMA

SCALE : AS GIVEN

DWNG TITLE : AS GIVN



D17M04Y25

WARNING:
- This drawing shall not be used for construction unless certified.
- Contractor to verify all dimensions of existing works on site before commencing any work or preparing shop drawings.
- Do not scale drawings, use written dimensions only.
- This drawing is to be read in conjunction with the specifications and conditions of contract.
- This drawing and design is copyright and no portion may be reproduced without the permission of the MACO architects

PANTRY
1.08 SCALE 1:20

ID08

- CL = CEILING LINE
- DCL = DROP CEILING LINE
- FFL = FLOOR FINISH LINE
- RFL = RAISED FLOOR LINE
- SFL = SUNKEN FLOOR LINE
- BL = BEAM LEVEL

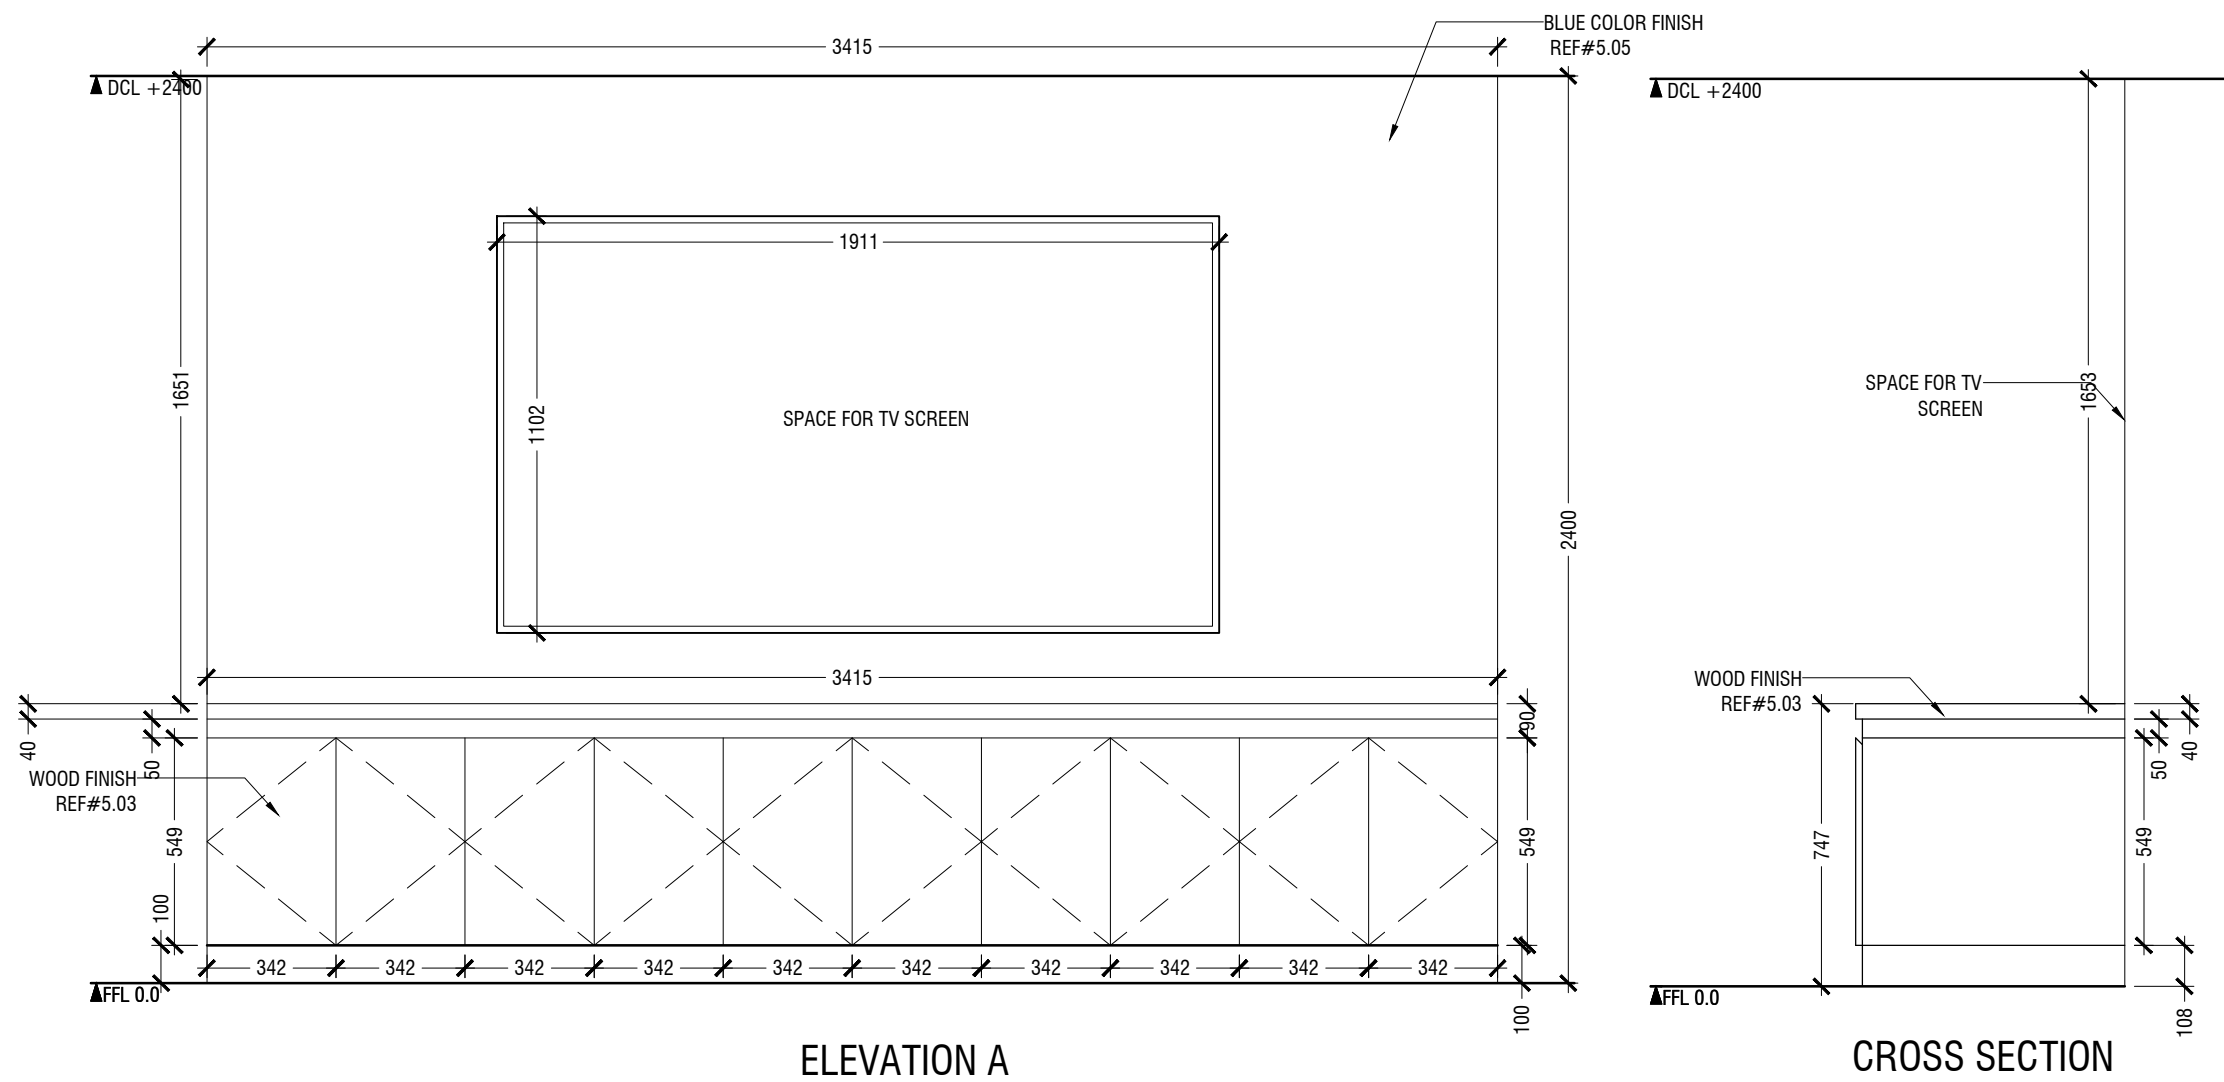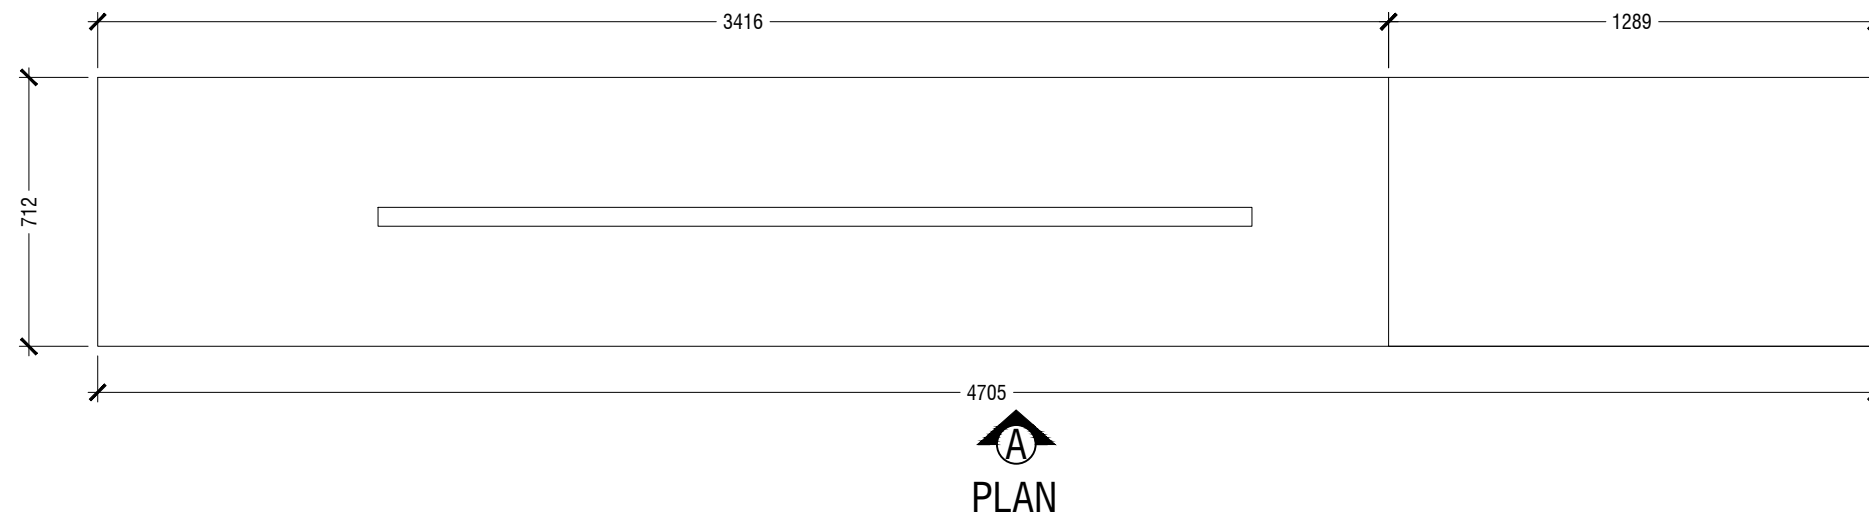

Contact: 7989966, 7691671
Email: info@maco.mv

CLIENT:

MINISTRY OF
EDUCATION

PROJECT:

MINISTRY OF
EDUCATION

INTERIOR DESIGNER

NAAJID
HASSAN
FATHIMA

SCALE : AS GIVEN

DWNG TITLE : AS GIVN

D17M04Y25




WARNING:

- This drawing shall not be used for construction unless certified.
- Contractors to verify all dimensions of existing works on site before commencing any work or preparing shop drawings.
- Do not scale drawings, use written dimensions only.
- This drawing is to be read in conjunction with the specifications and conditions of contract.
- This drawing and design is copyright and no portion may be reproduced without the permission of the MACO architects

1.09 TV CONSOLE
LOCATION " MEETING ROOM "
SCALE 1:20

ID09

- NOTE
- CL = CEILING LINE
 - DCL = DROP CEILING LINE
 - FFL = FLOOR FINISH LINE
 - RFL = RAISED FLOOR LINE
 - SFL = SUNKEN FLOOR LINE
 - BL = BEAM LEVEL

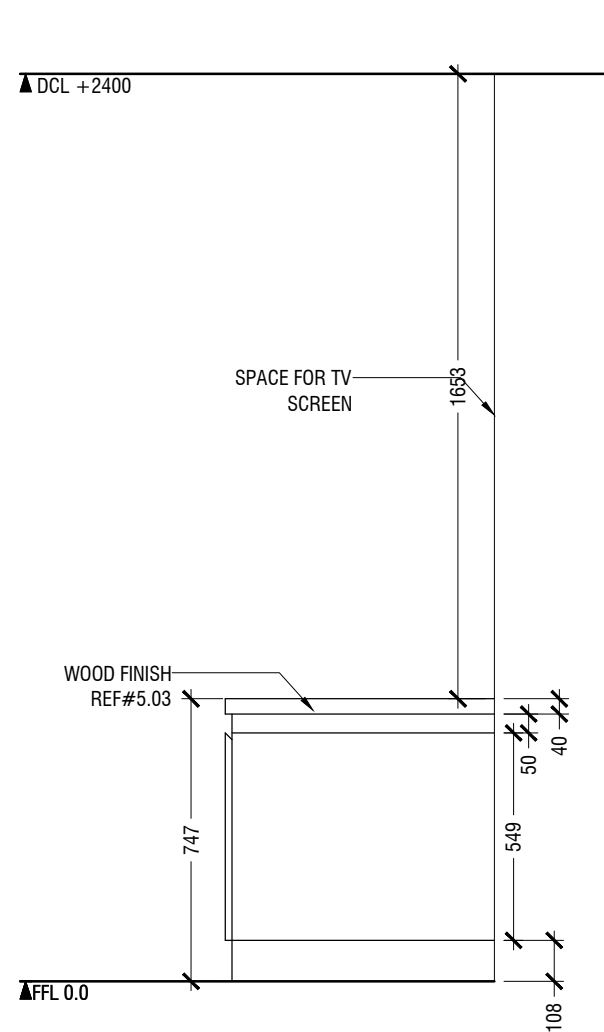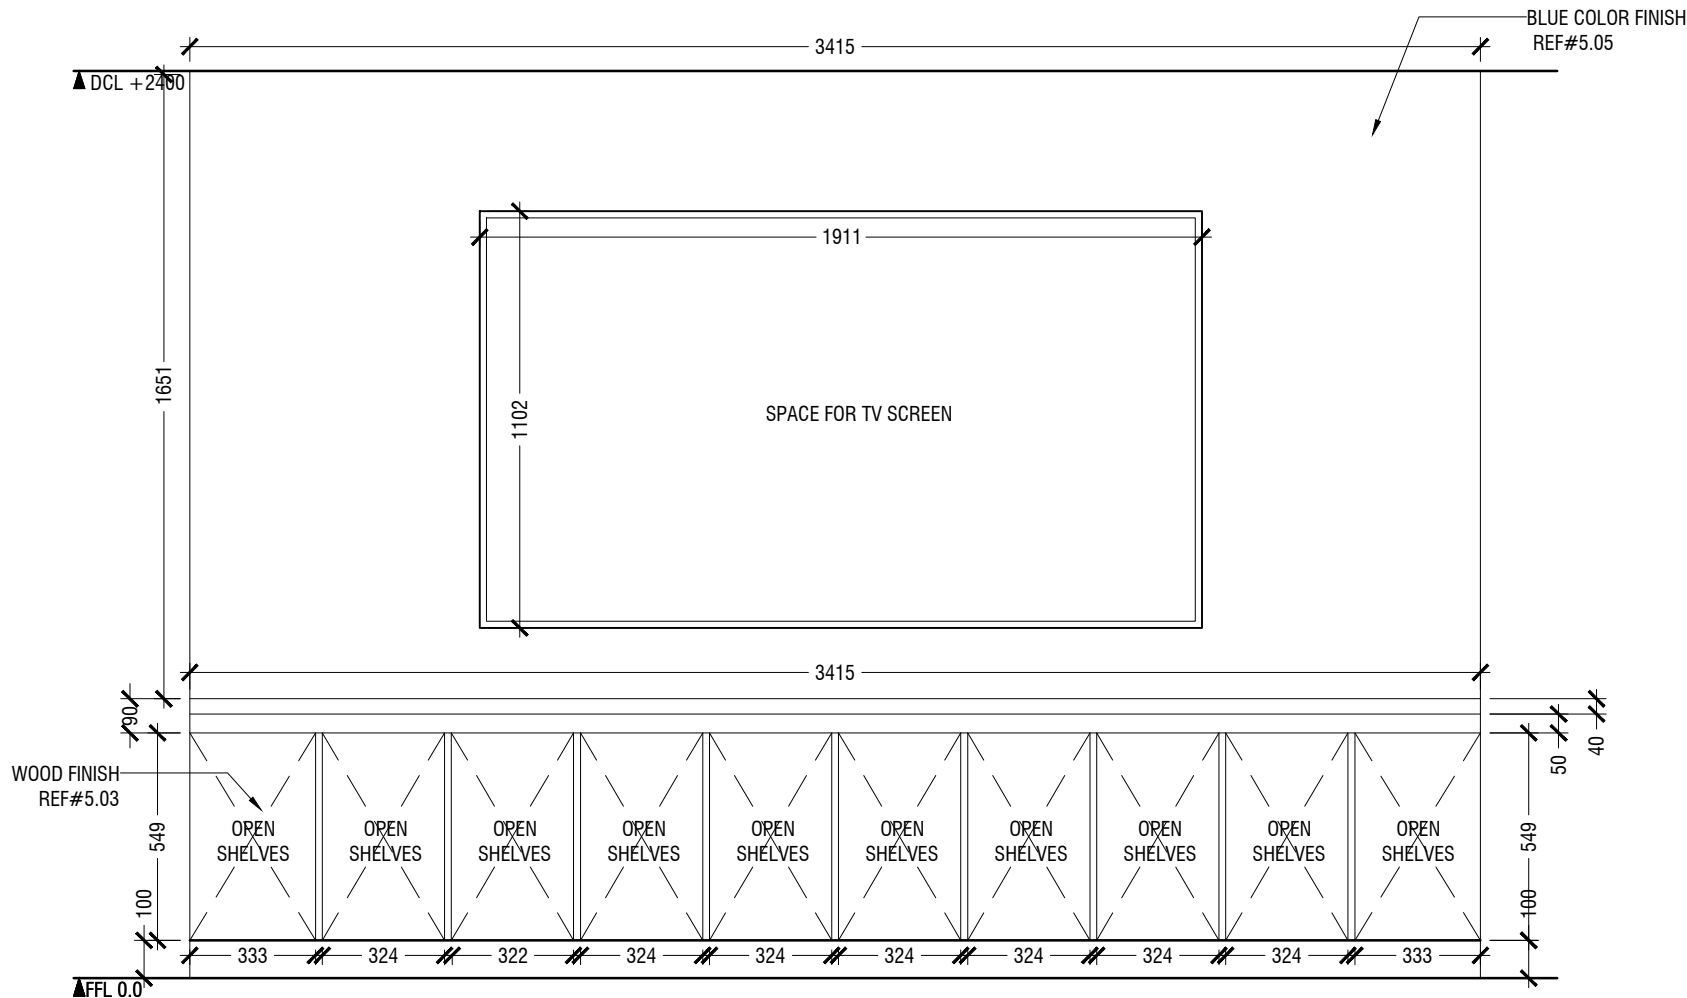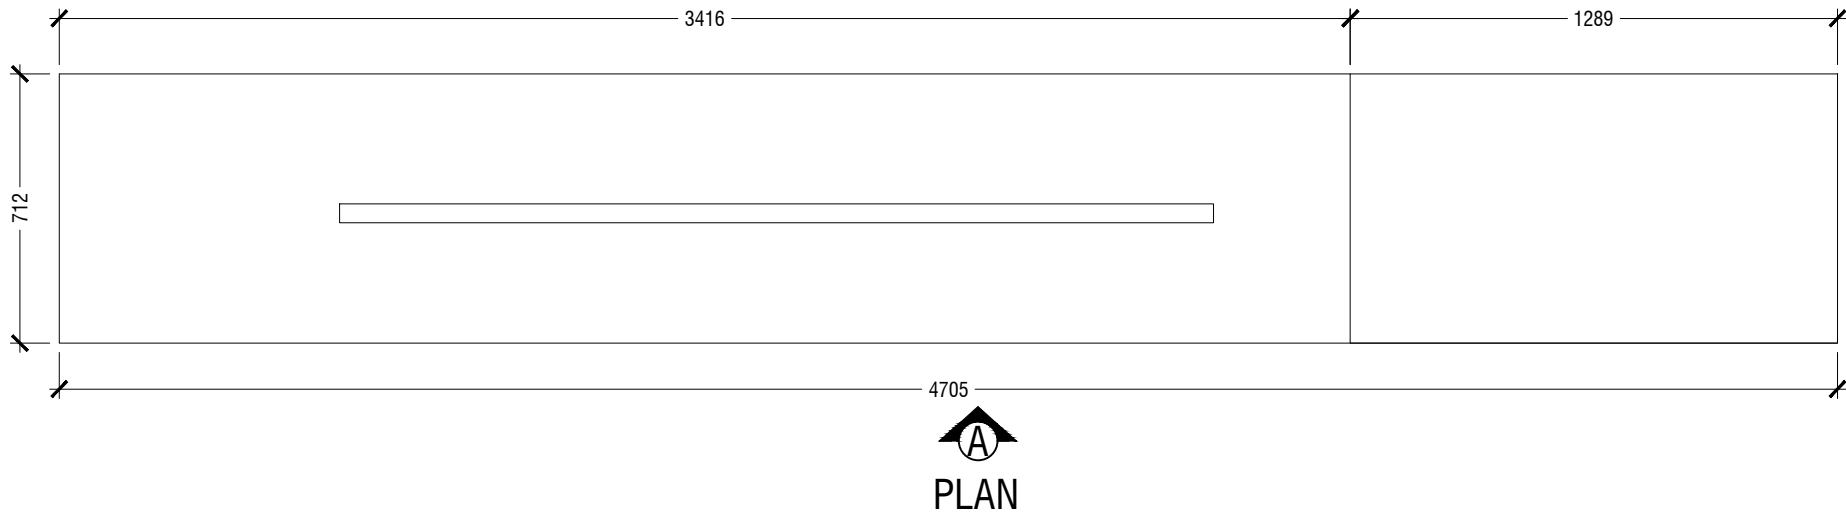

MACO
DESIGNS

Contact: 7989966, 7691671
Email: info@maco.mv

CLIENT:

MINISTRY OF
EDUCATION

PROJECT:

MINISTRY OF
EDUCATION

INTERIOR DESIGNER

NAAJID
HASSAN
FATHIMA

SCALE : AS GIVEN

DWNG TITLE : AS GIVN


D17M04Y25

WARNING:
- This drawing shall not be used for construction unless certified.
- Contractor to verify all dimensions of existing works on site before commencing any work or preparing shop drawings.
- Do not scale drawings, use written dimensions only.
- This drawing is to be read in conjunction with the specifications and conditions of contract.
- This drawing and design is copyright and no portion may be reproduced without the permission of the MACO architects


1.09 TV CONSOLE
LOCATION "MEETING ROOM "
SCALE 1:20

ID10


- NOTE
- CL = CEILING LINE
 - DCL = DROP CEILING LINE
 - FFL = FLOOR FINISH LINE
 - RFL = RAISED FLOOR LINE
 - SFL = SUNKEN FLOOR LINE
 - BL = BEAM LEVEL

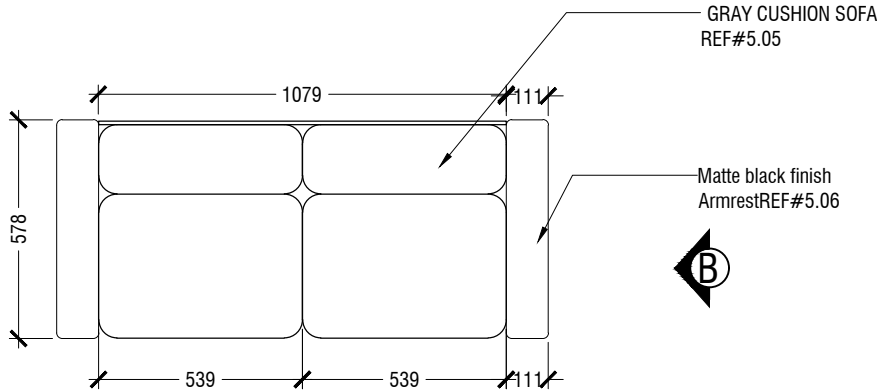

A
PLAN

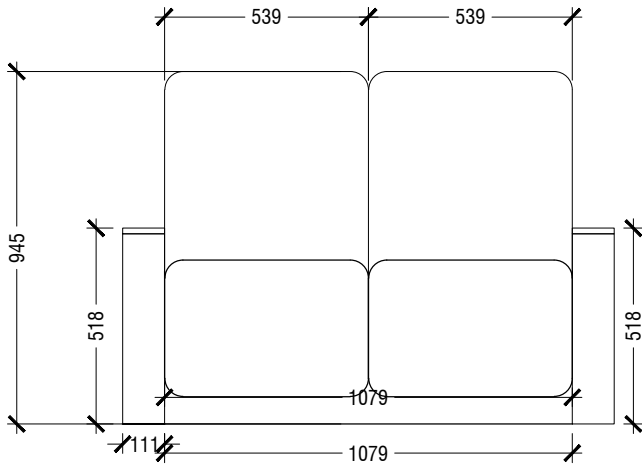

ELEVATION A

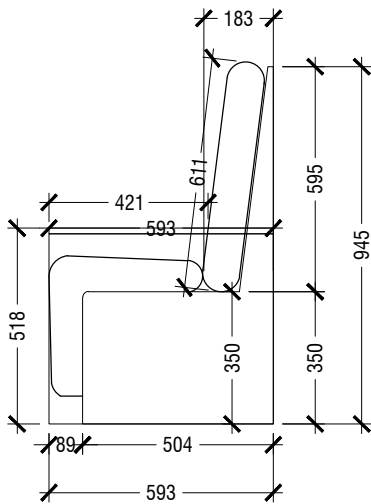

ELEVATION B



Contact: 7989966, 7691671
Email: info@maco.mv

CLIENT:

MINISTRY OF
EDUCATION

PROJECT:

MINISTRY OF
EDUCATION

INTERIOR DESIGNER

NAAJID
HASSAN
FATHIMA

SCALE : AS GIVEN




DWNG TITLE : AS GIVN

D17M04Y25

WARNING:
- This drawing shall not be used for construction unless certified.
- Contractor to verify all dimensions of existing works on site before commencing any work or preparing shop drawings.
- Do not scale drawings, use written dimensions only.
- This drawing is to be read in conjunction with the specifications and conditions of contract.
- This drawing and design is copyright and no portion may be reproduced without the permission of the MACO architects

ID11

1.10 COUCH
LOCATION "MEETING ROOM "
SCALE 1:20

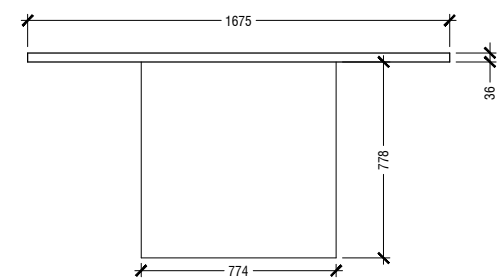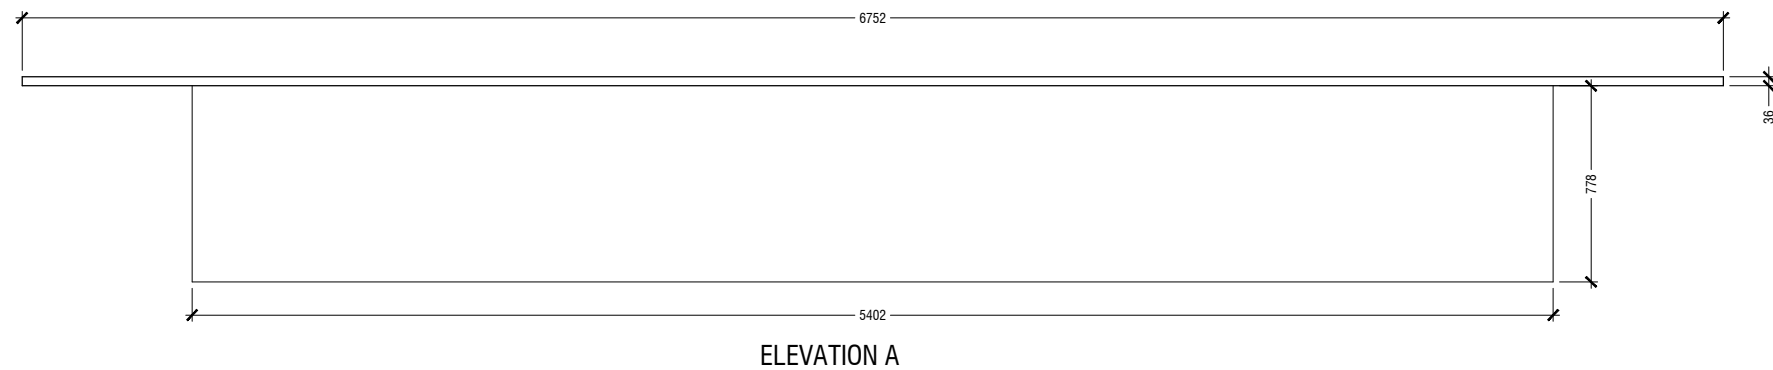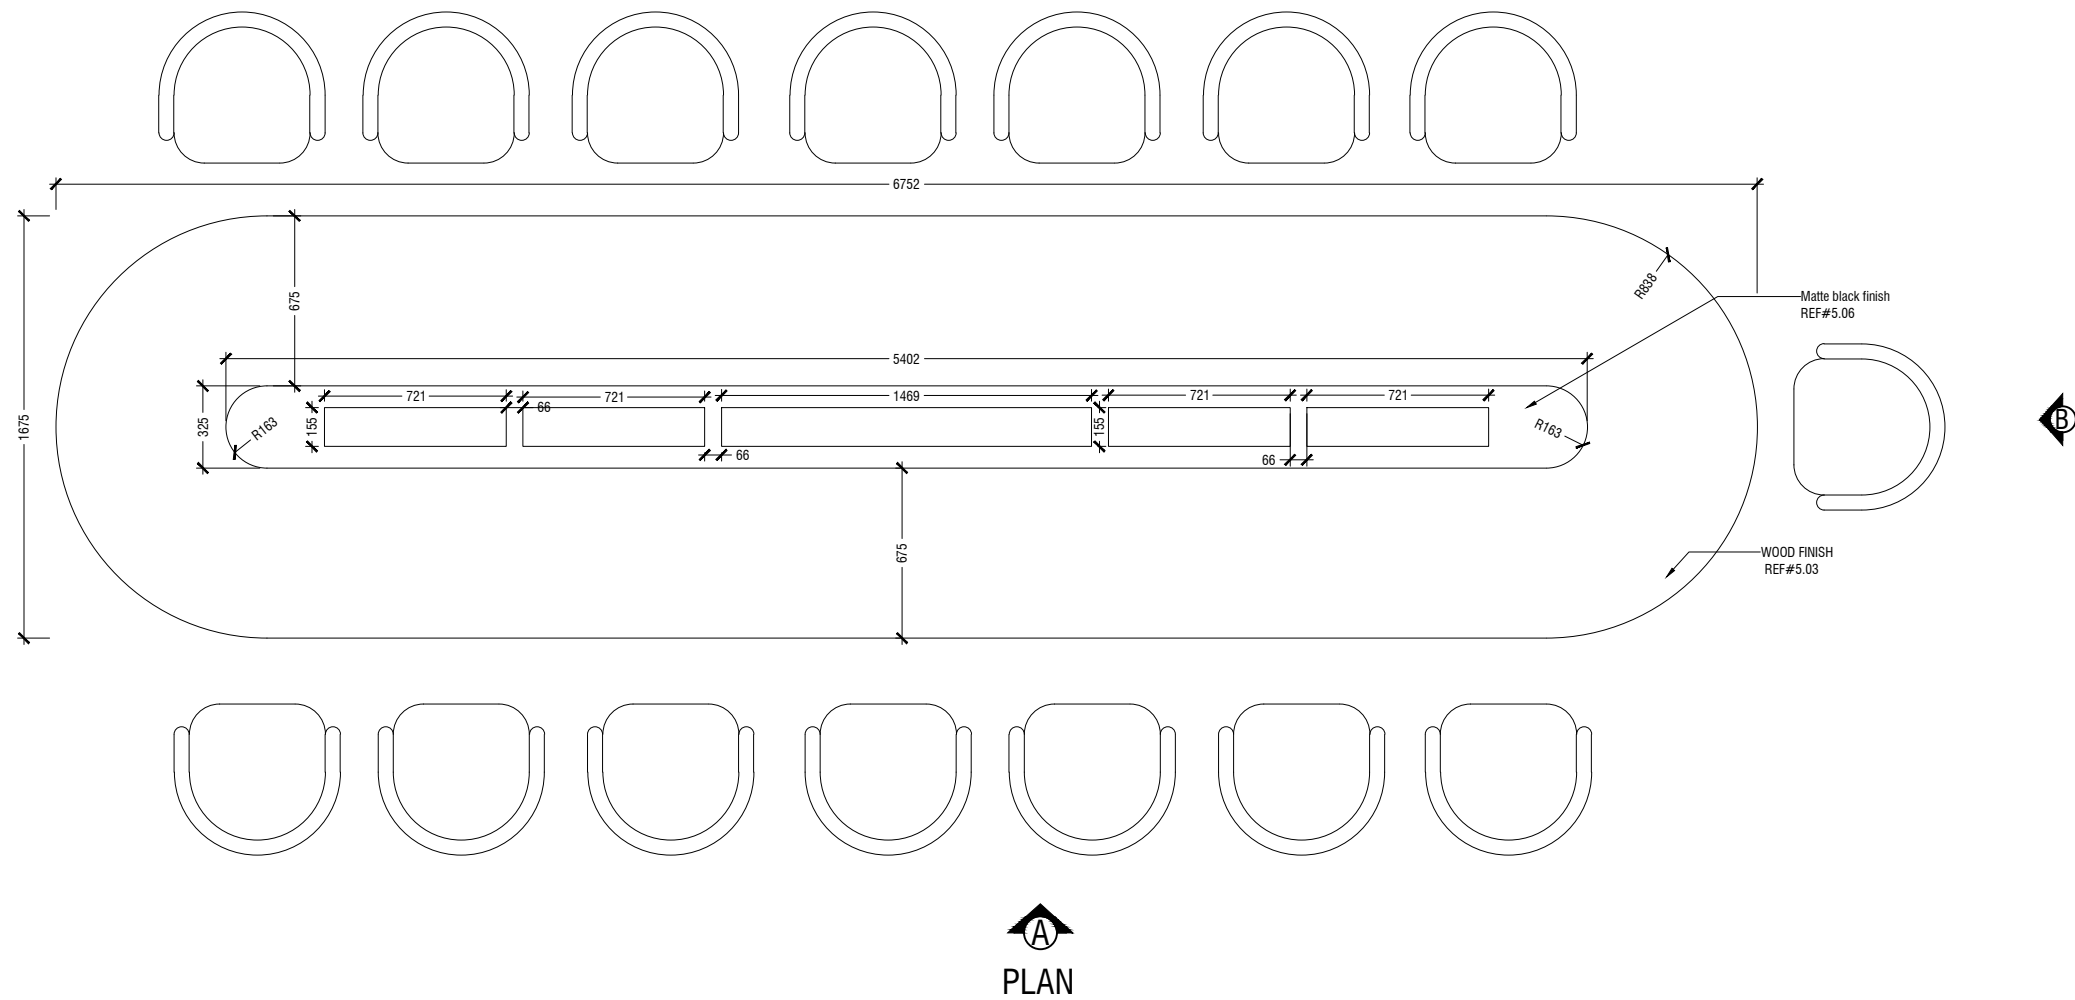

MEETING TABLE
LOCATION "MEETING ROOM "
SCALE 1:30

MACO
DESIGNS
Contact: 7989966, 7691671
Email: info@maco.mv

CLIENT:

MINISTRY OF
EDUCATION

PROJECT:

MINISTRY OF
EDUCATION

INTERIOR DESIGNER

NAAJID
HASSAN
FATHIMA

SCALE : AS GIVEN


DWNG TITLE : AS GIVN

D17M04Y25

WARNING:
- This drawing shall not be used for construction unless certified.
- Contractor to verify all dimensions of existing works on site before commencing any work or preparing shop drawings.
- Do not scale drawings, use written dimensions only.
- This drawing is to be read in conjunction with the specifications and conditions of contract.
- This drawing and design is copyright and no portion may be reproduced without the permission of the MACO architects

ID12

- NOTE
- CL = CEILING LINE
 - DCL = DROP CEILING LINE
 - FFL = FLOOR FINISH LINE
 - RFL = RAISED FLOOR LINE
 - SFL = SUNKEN FLOOR LINE
 - BL = BEAM LEVEL

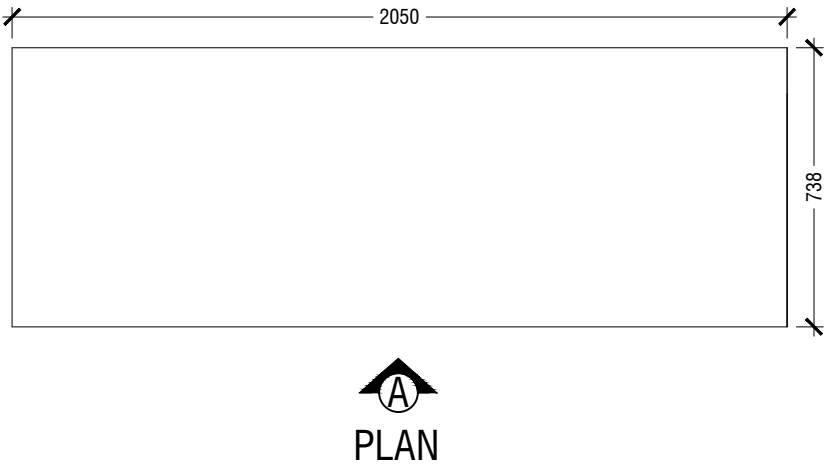


NO of pa x 6


DCL +2400

▲ DCL +2400


▲ DCL +2400

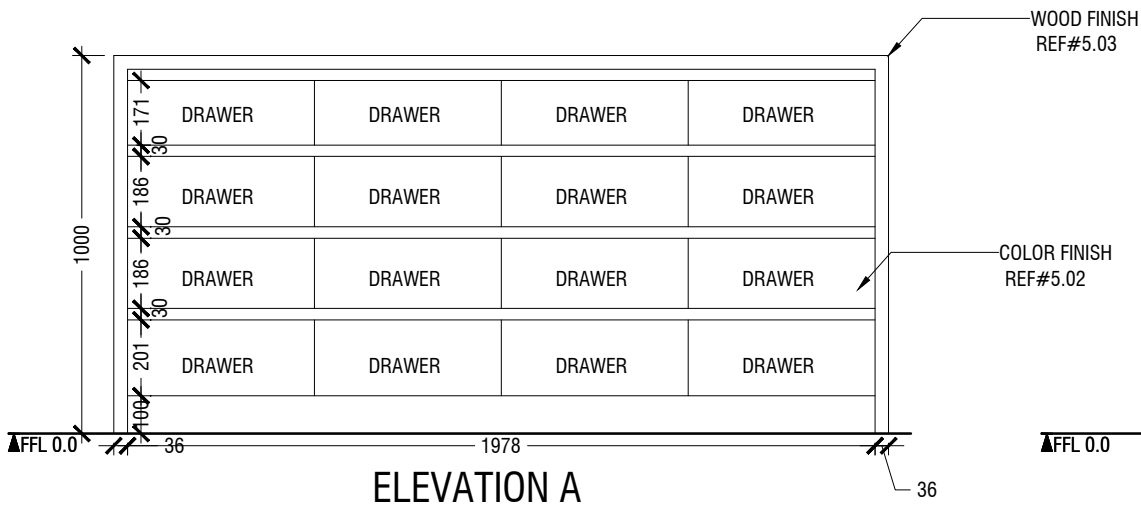

ELEVATION A

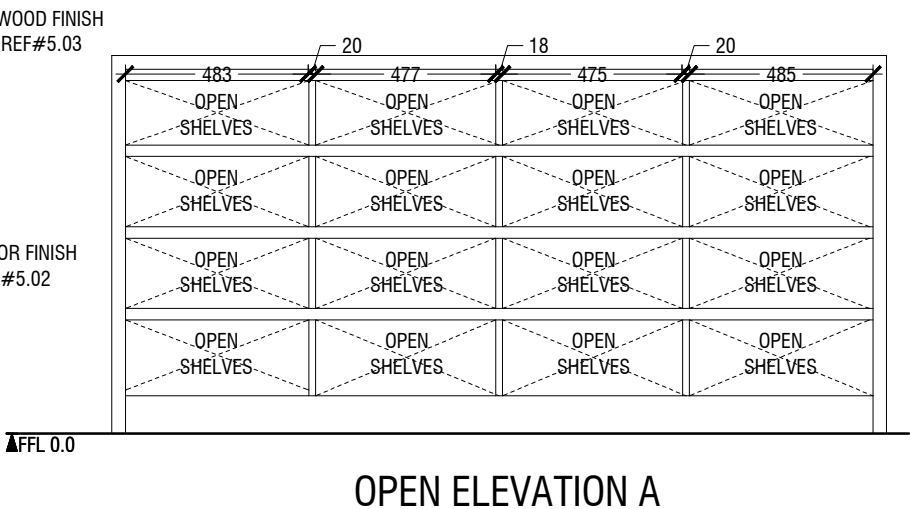

OPEN ELEVATION A

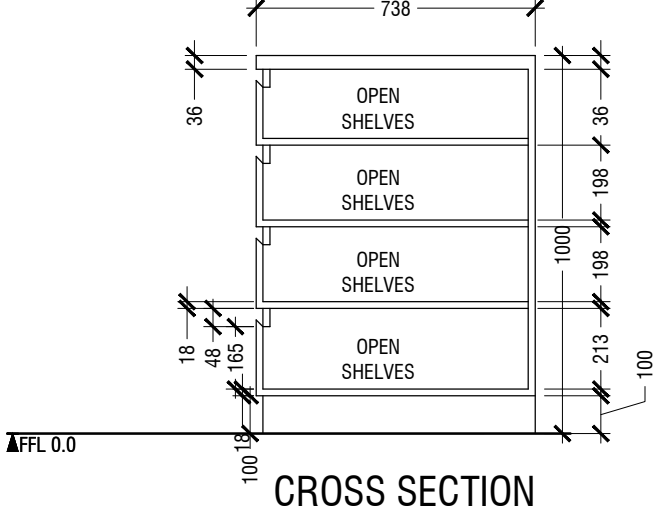

CROSS SECTION

1.12 STORAGE
SCALE 1:20

MACO
DESIGNS

Contact: 7989966, 7691671
Email: info@maco.mv

CLIENT:

MINISTRY OF
EDUCATION

PROJECT:

MINISTRY OF
EDUCATION

INTERIOR DESIGNER

NAAJID
HASSAN
FATHIMA

SCALE : AS GIVEN


DWNG TITLE : AS GIVN

D17M04Y25

WARNING:
- This drawing shall not be used for construction unless certified.
- Contractor to verify all dimensions of existing works on site before commencing any work or preparing shop drawings.
- Do not scale drawings, use written dimensions only.
- This drawing is to be read in conjunction with the specifications and conditions of contract.
- This drawing and design is copyright and no portion may be reproduced without the permission of the MACO architects

ID13

- NOTE
- CL = CEILING LINE
 - DCL = DROP CEILING LINE
 - FFL = FLOOR FINISH LINE
 - RFL = RAISED FLOOR LINE
 - SFL = SUNKEN FLOOR LINE
 - BL = BEAM LEVEL

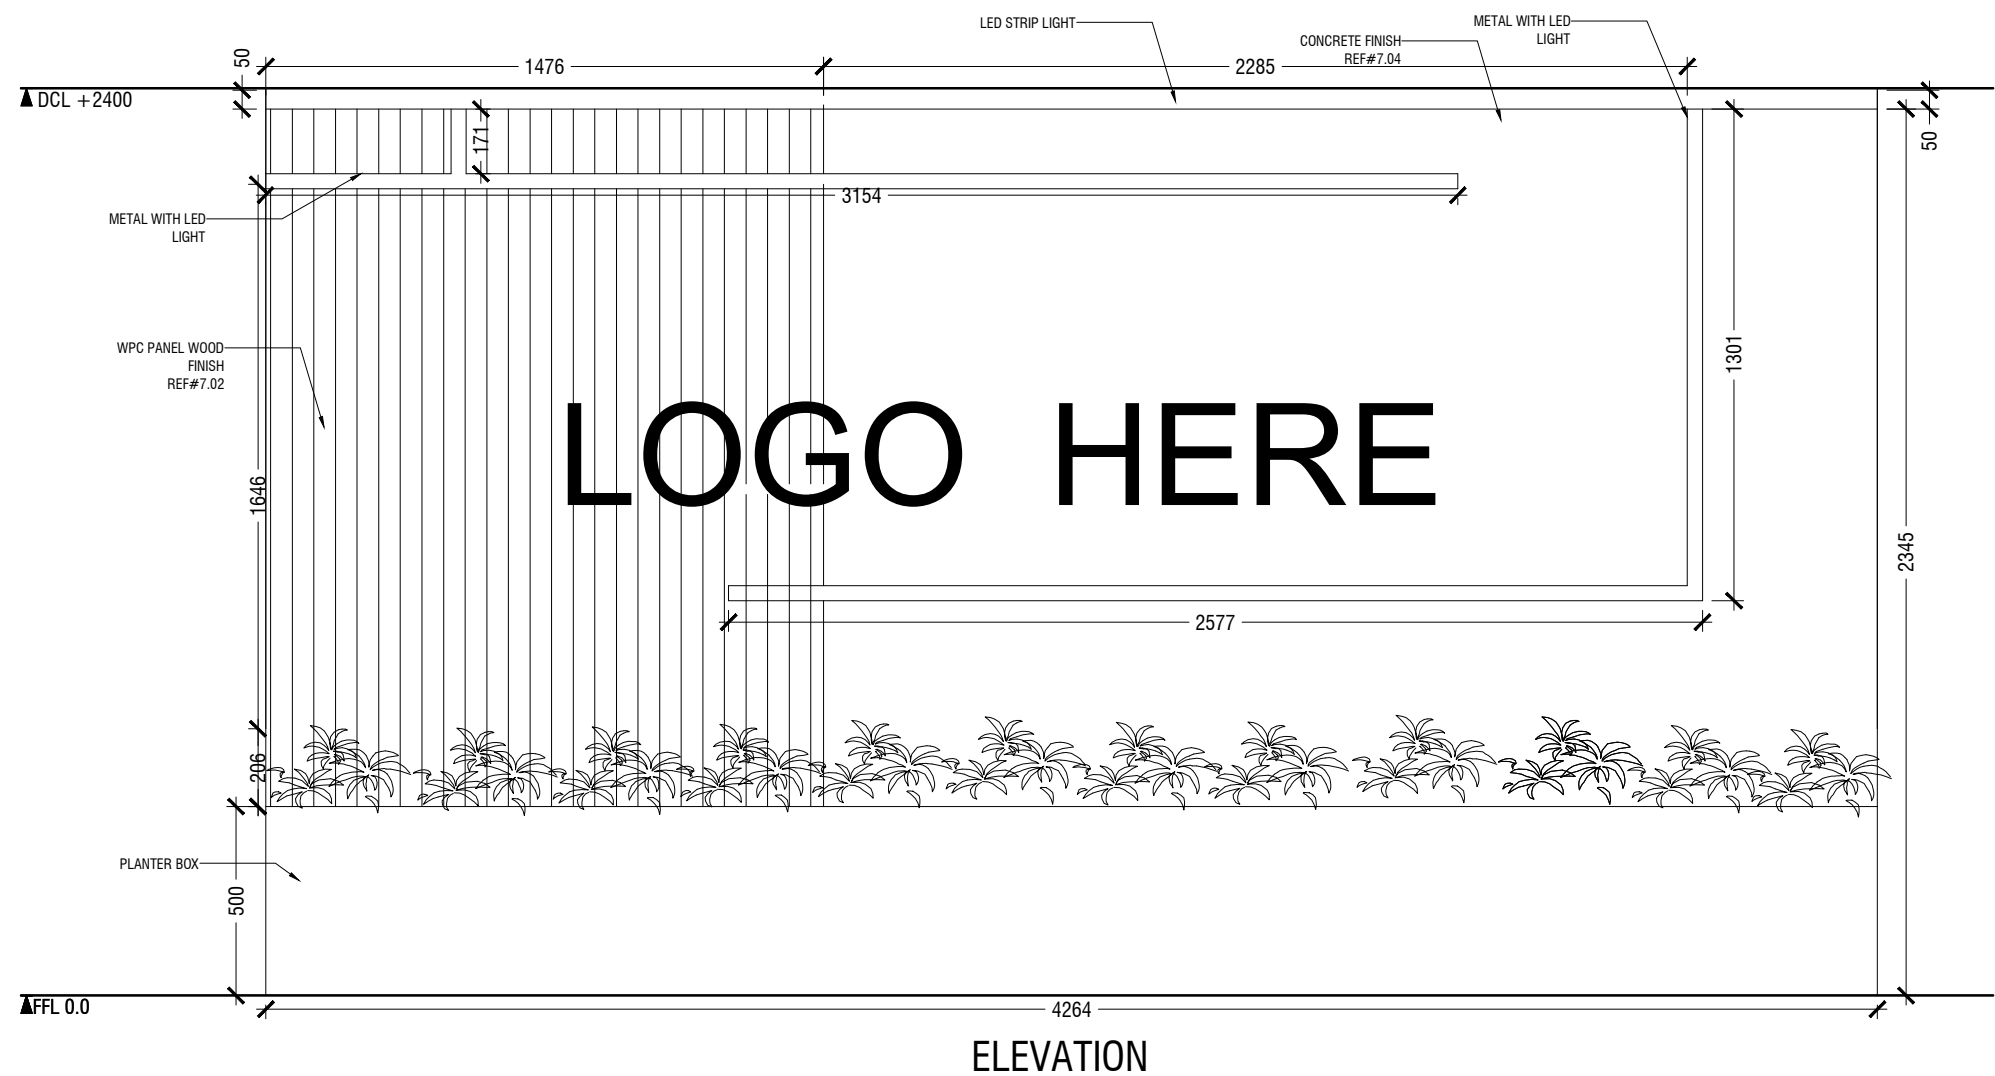

ELEVATION



Contact: 7989966, 7691671
Email: info@maco.mv

CLIENT:

MINISTRY OF
EDUCATION

PROJECT:

MINISTRY OF
EDUCATION

INTERIOR DESIGNER

NAAJID
HASSAN
FATHIMA

SCALE : AS GIVEN

DWNG TITLE : AS GIVN

D17M04Y25

WARNING:
- This drawing shall not be used for construction unless certified.
- Contractor to verify all dimensions of existing works on site before commencing any work or preparing shop drawings.
- Do not scale drawings, use written dimensions only.
- This drawing is to be read in conjunction with the specifications and conditions of contract.
- This drawing and design is copyright and no portion may be reproduced without the permission of the MACO architects

2.01 FEATURE WALL
LOCATION " ENTRY WALKWAY "
SCALE 1:20

ID14